



Sheet List		
Sheet Number	Sheet Name	Drawn By
A0	TABLE OF CONTENTS	Joshua Tio
A1.1	SITE PLAN	Joshua Tio
A2.1	FLOOR PLAN LEVEL 1	Joshua Tio
A2.2	FLOOR PLAN LEVEL 2	Joshua Tio
A2.3	PRESENTATION PLAN LEVEL 1	Joshua Tio
A2.4	PRESENTATION PLAN LEVEL 2	Joshua Tio
A2.5	FOUNDATION PLAN	Joshua Tio
A2.6	ELECTRICAL PLAN LEVEL 1	Joshua Tio
A2.7	ELECTRICAL PLAN LEVEL 2	Joshua Tio
A3.1	NORTH & SOUTH ELEVATION	Joshua Tio
A3.2	EAST & WEST ELEVATION	Joshua Tio
A4.1	BUILDING SECTION 1	Joshua Tio
A4.2	BUILDING SECTION 2	Joshua Tio
A4.3	WALL SECTIONS	Joshua Tio
A5.1	SCHEDULES	Joshua Tio
A6.1	DETAILS	Joshua Tio
A7.1	INTERIOR ELEVATIONS	Joshua Tio
A8.1	HOUSE VIEWS	Joshua Tio
A8.2	HOUSE VIEWS	Joshua Tio



Saddleback College

www.saddleback.edu

Consultant
Address
Address
Phone
Fax
e-mail

Consultant
Address
Address
Phone
Fax
e-mail

Consultant
Address
Address
Phone
Fax
e-mail

Consultant
Address
Address
Phone
Fax
e-mail

Consultant
Address
Address
Phone
Fax
e-mail

No.	Description	Date

Joshua Tio

ARCH 150 FINAL

TABLE OF CONTENTS

Project number	EX03
Date	7-15-2026
Drawn by	Joshua Tio
Checked by	Serafim Gulin

A0




Consultant
Address
Address
Phone
Fax
e-mail

Joshua Tio
ARCH 150 FINAL
SITE PLAN

A1.1

1/8" = 1'-0"

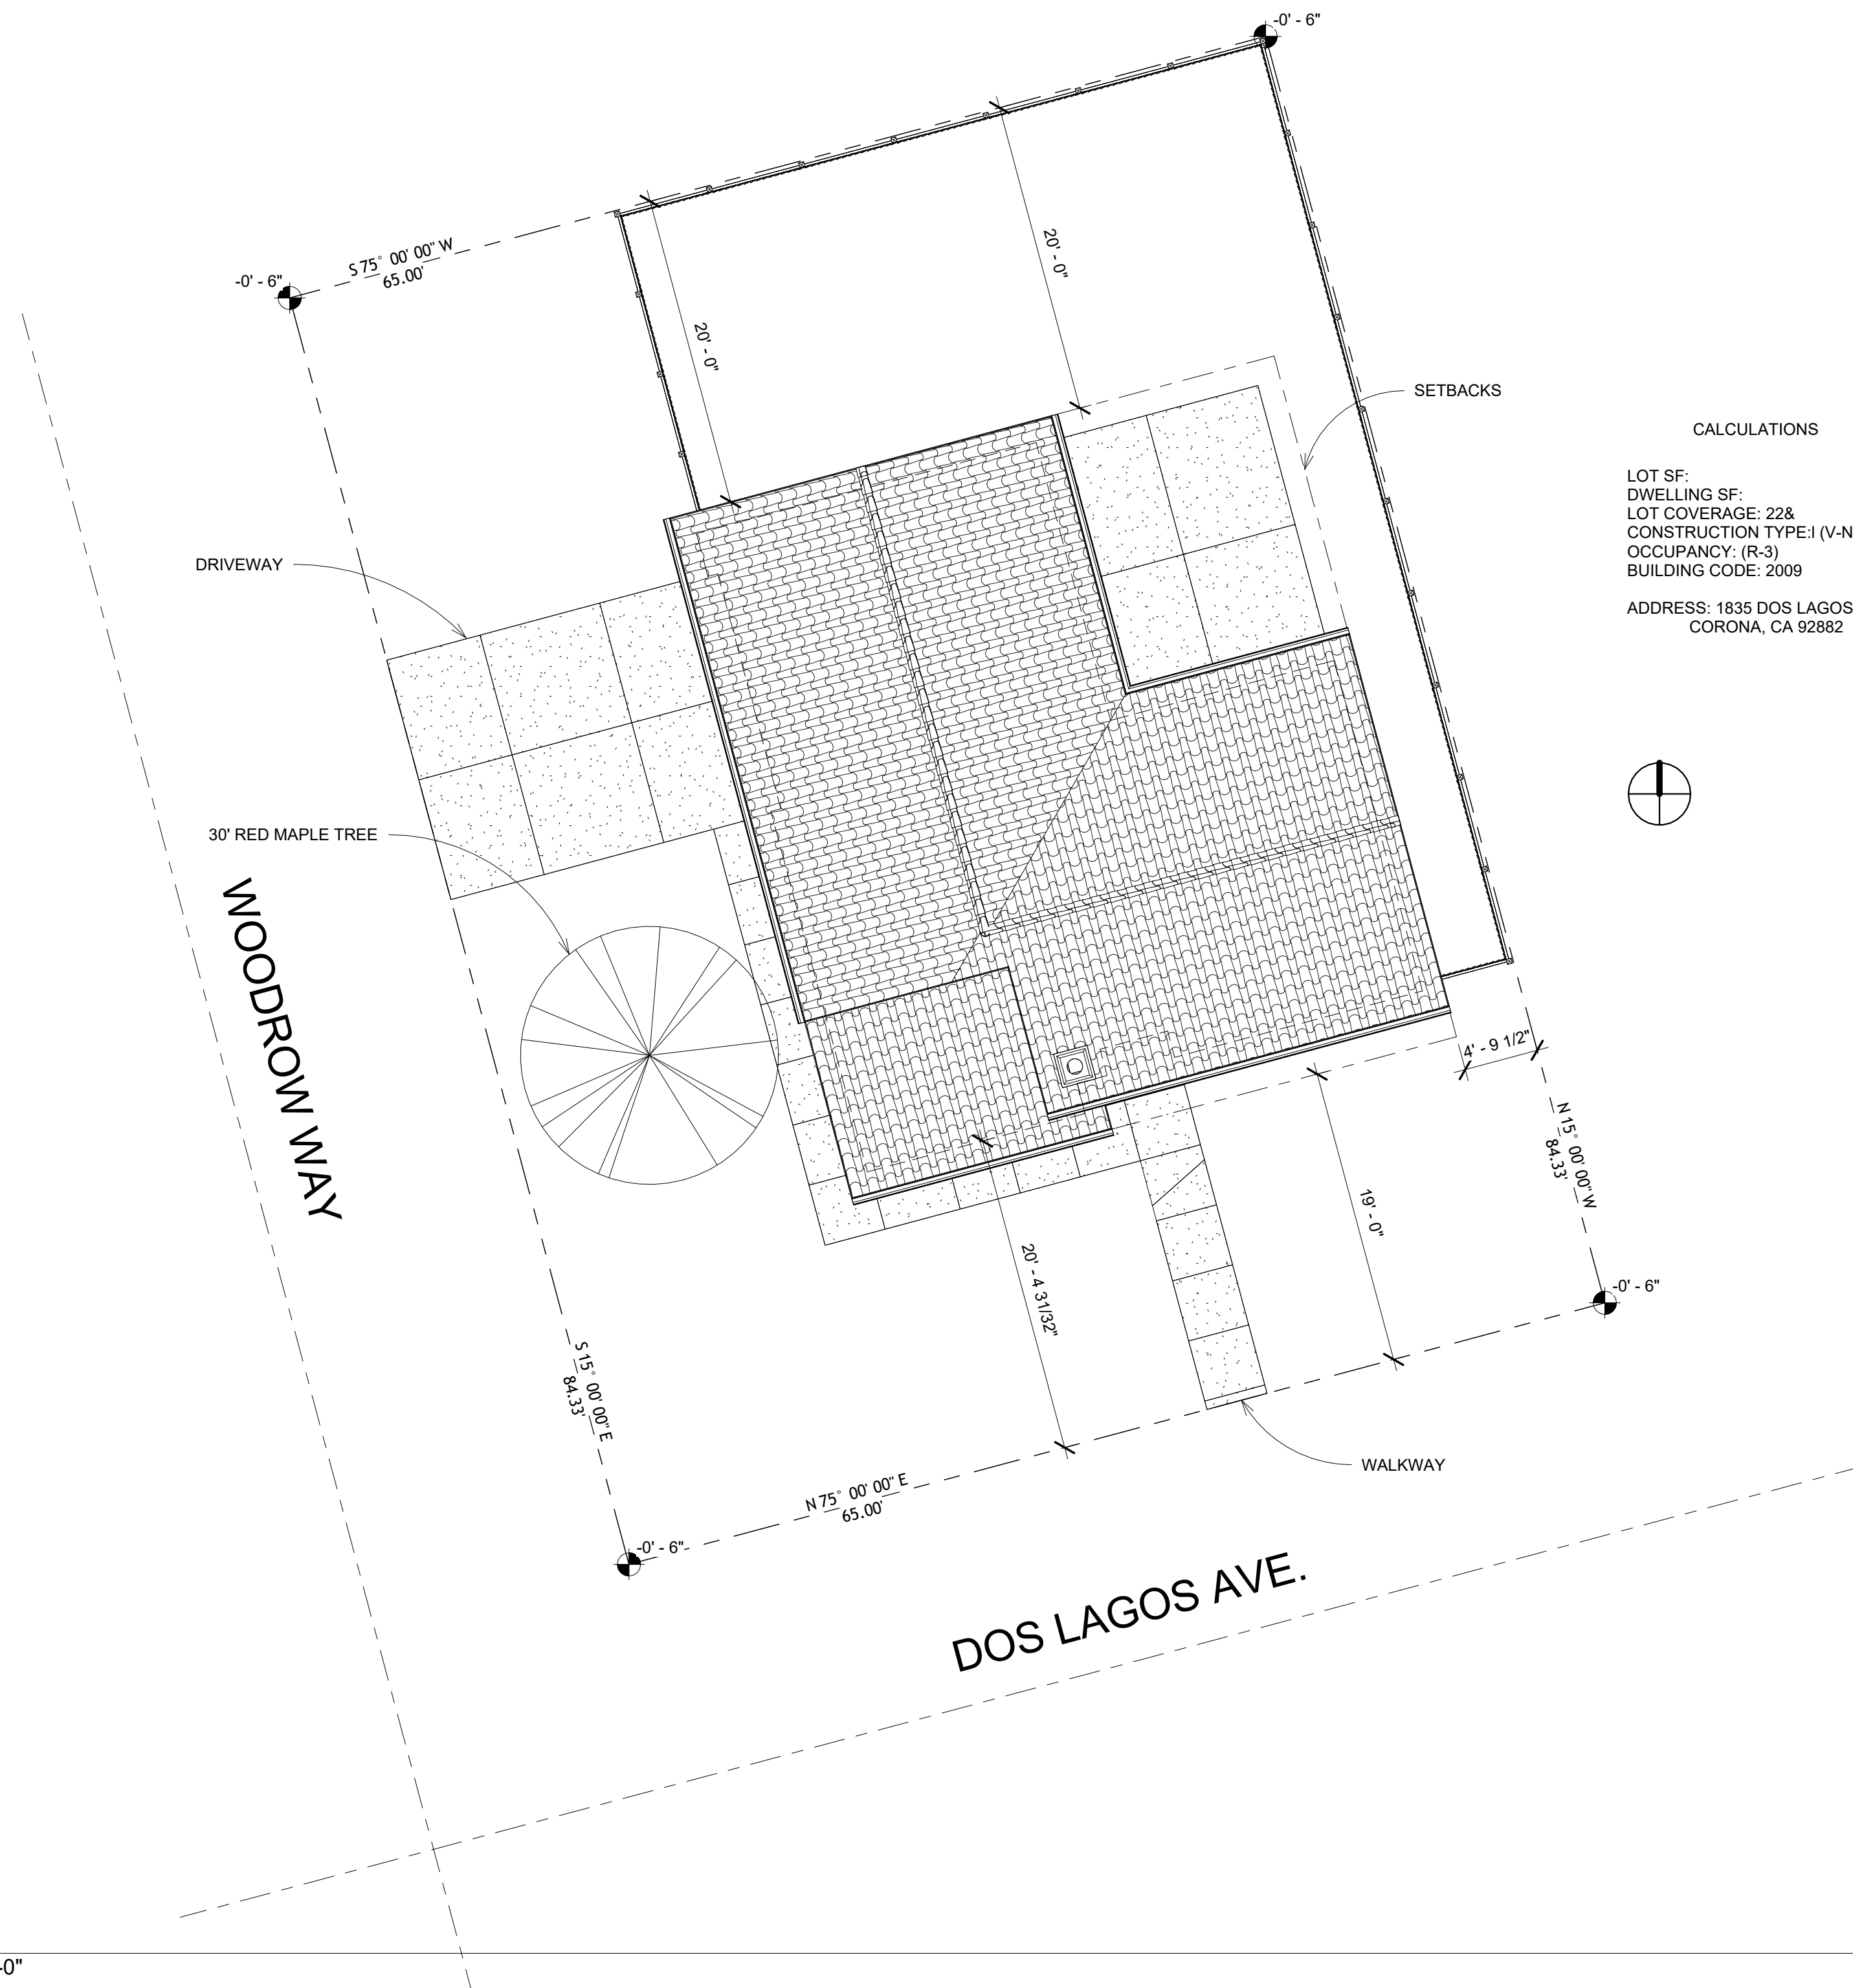

1 Site
1/8" = 1'-0"



Saddleback College

www.saddleback.edu

Consultant
Address
Address
Phone
Fax
e-mail

Consultant
Address
Address
Phone
Fax
e-mail

Consultant
Address
Address
Phone
Fax
e-mail

Consultant
Address
Address
Phone
Fax
e-mail

Consultant
Address
Address
Phone
Fax
e-mail


No.	Description	Date

Joshua Tio
ARCH 150 FINAL
FLOOR PLAN
LEVEL 1

Project number	EX03
Date	7-15-2026
Drawn by	Joshua Tio
Checked by	Checker

A2.1

1/4" = 1'-0"

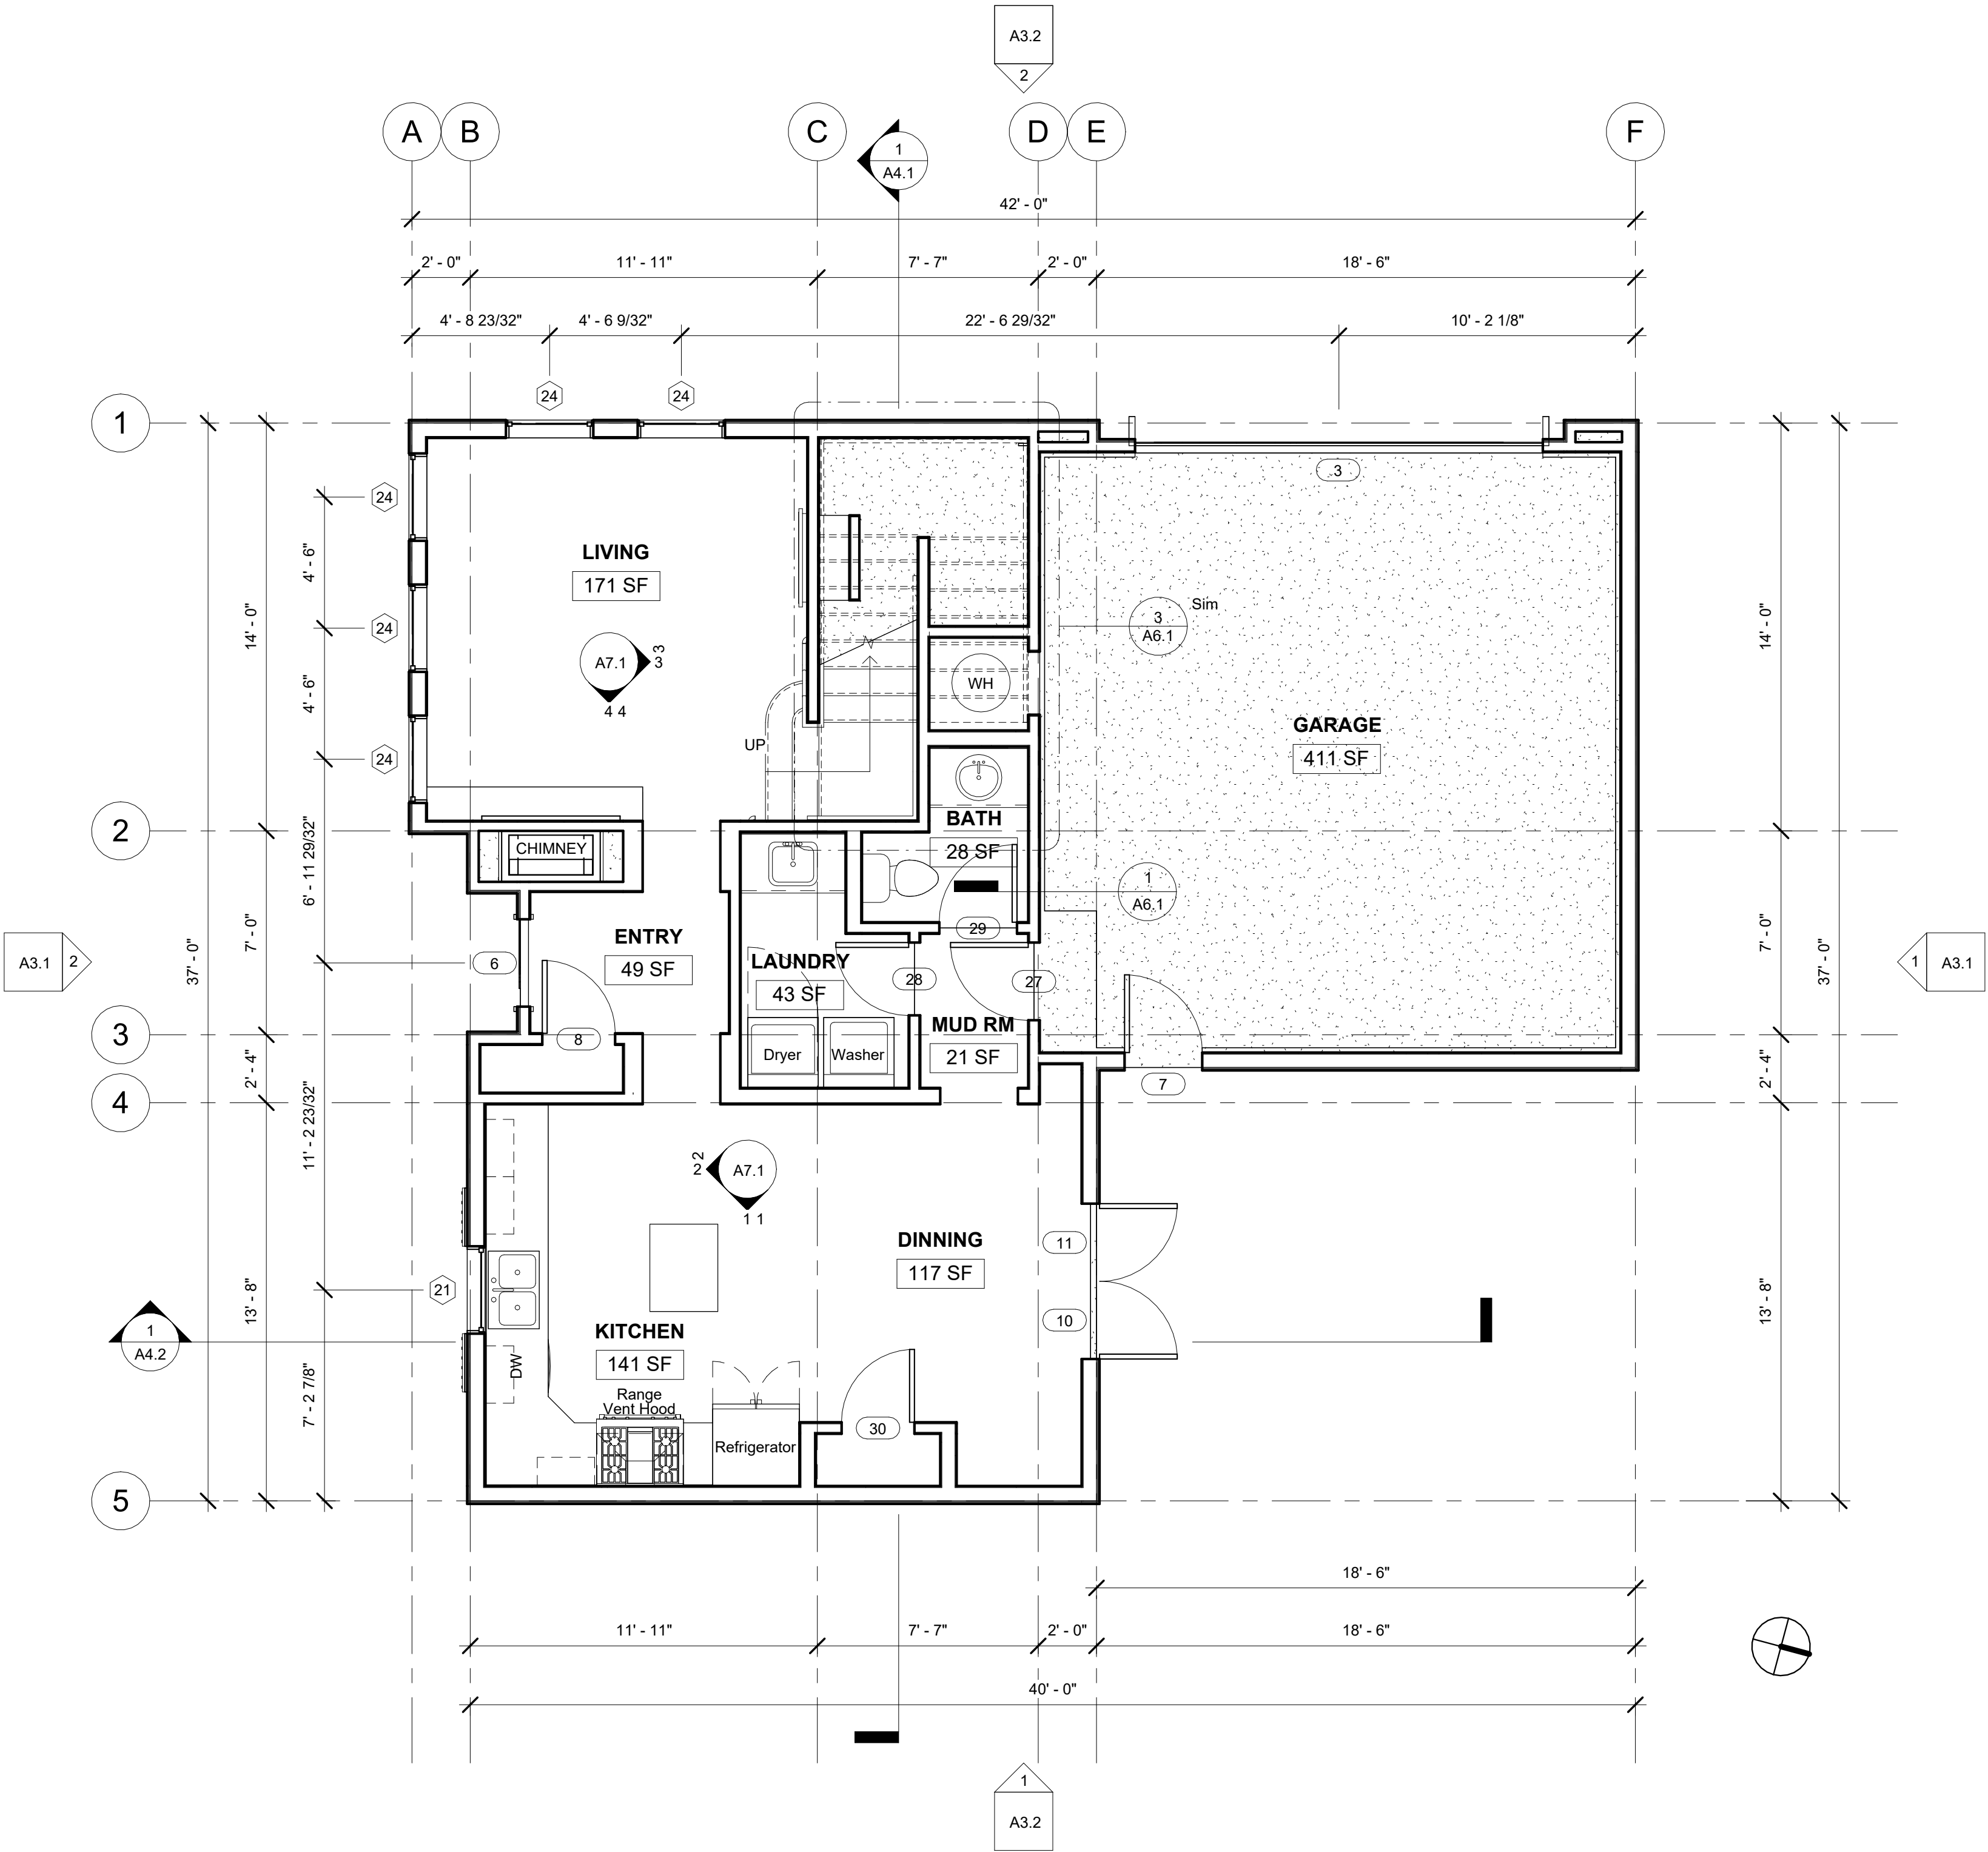

1 1st Floor
1/4" = 1'-0"



Saddleback College

www.saddleback.edu

Consultant
Address
Address
Phone
Fax
e-mail

Consultant
Address
Address
Phone
Fax
e-mail

Consultant
Address
Address
Phone
Fax
e-mail

Consultant
Address
Address
Phone
Fax
e-mail

Consultant
Address
Address
Phone
Fax
e-mail


No.	Description	Date

Joshua Tio
ARCH 150 FINAL
FLOOR PLAN
LEVEL 2

Project number	EX03
Date	7-15-2026
Drawn by	Joshua Tio
Checked by	Checker

A2.2

1/4" = 1'-0"

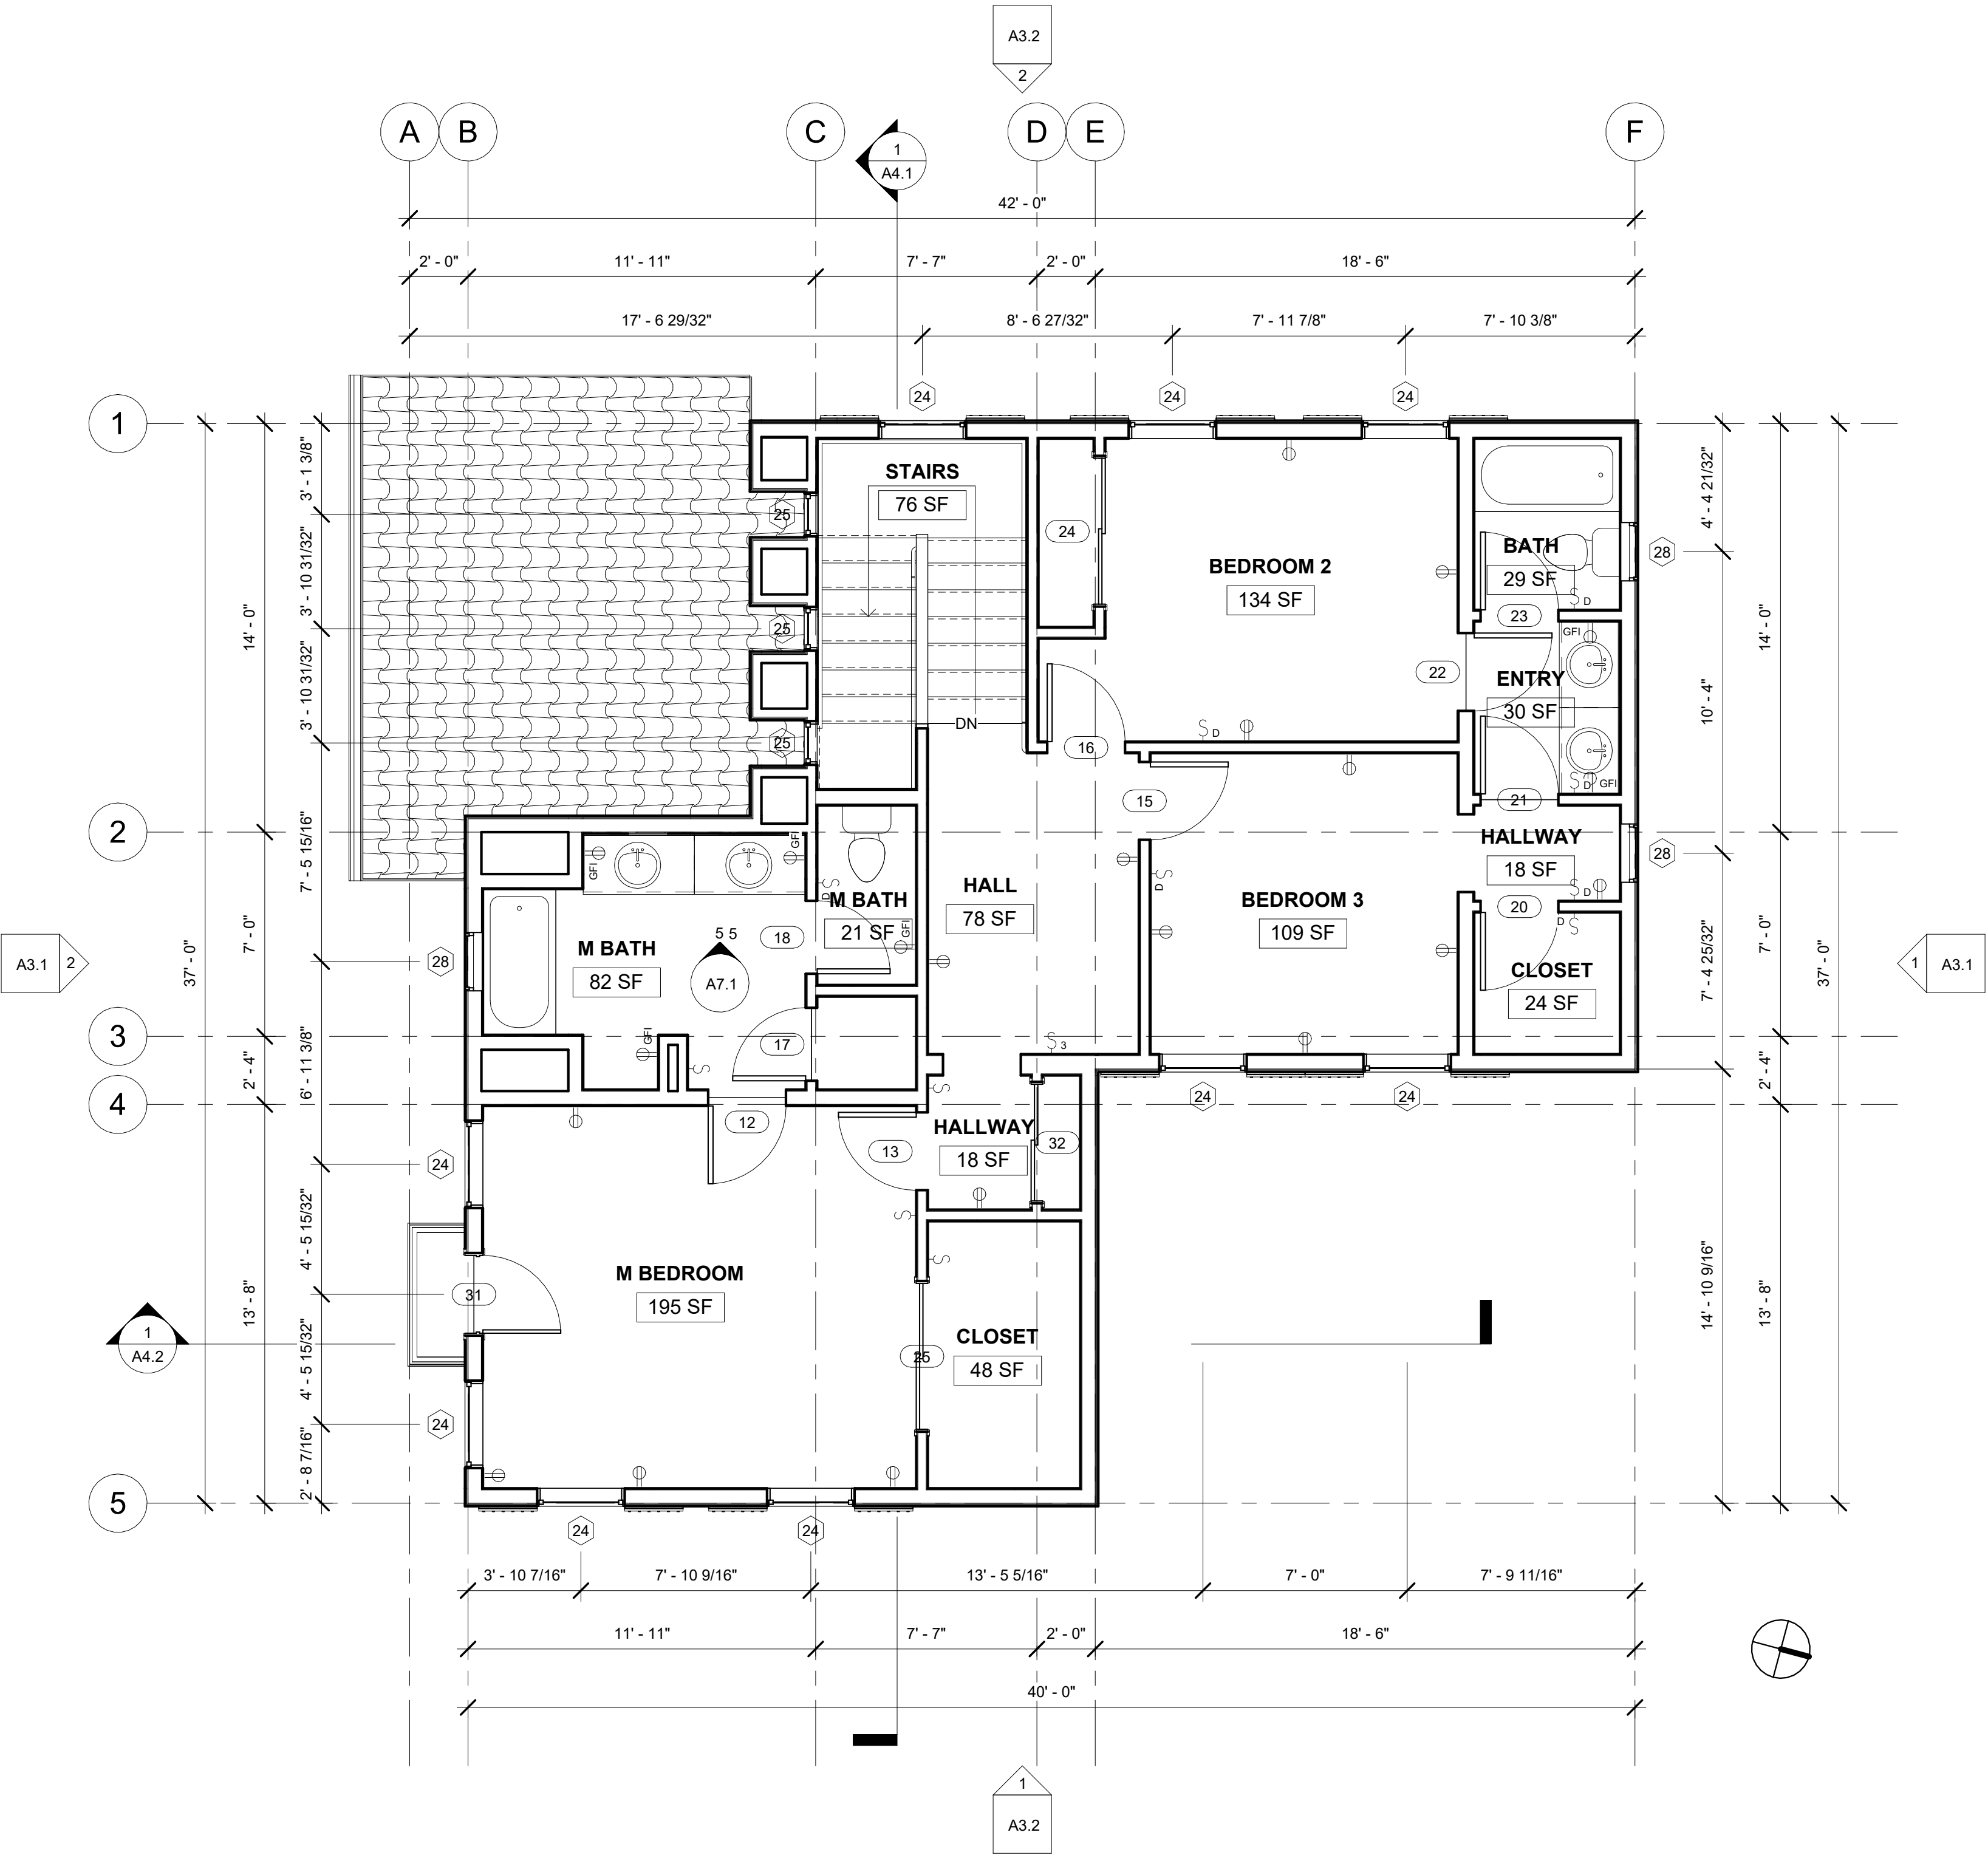



Saddleback College

www.saddleback.edu


Consultant
Address
Address
Phone
Fax
e-mail

Consultant
Address
Address
Phone
Fax
e-mail

Consultant
Address
Address
Phone
Fax
e-mail


Consultant
Address
Address
Phone
Fax
e-mail

Consultant
Address
Address
Phone
Fax
e-mail

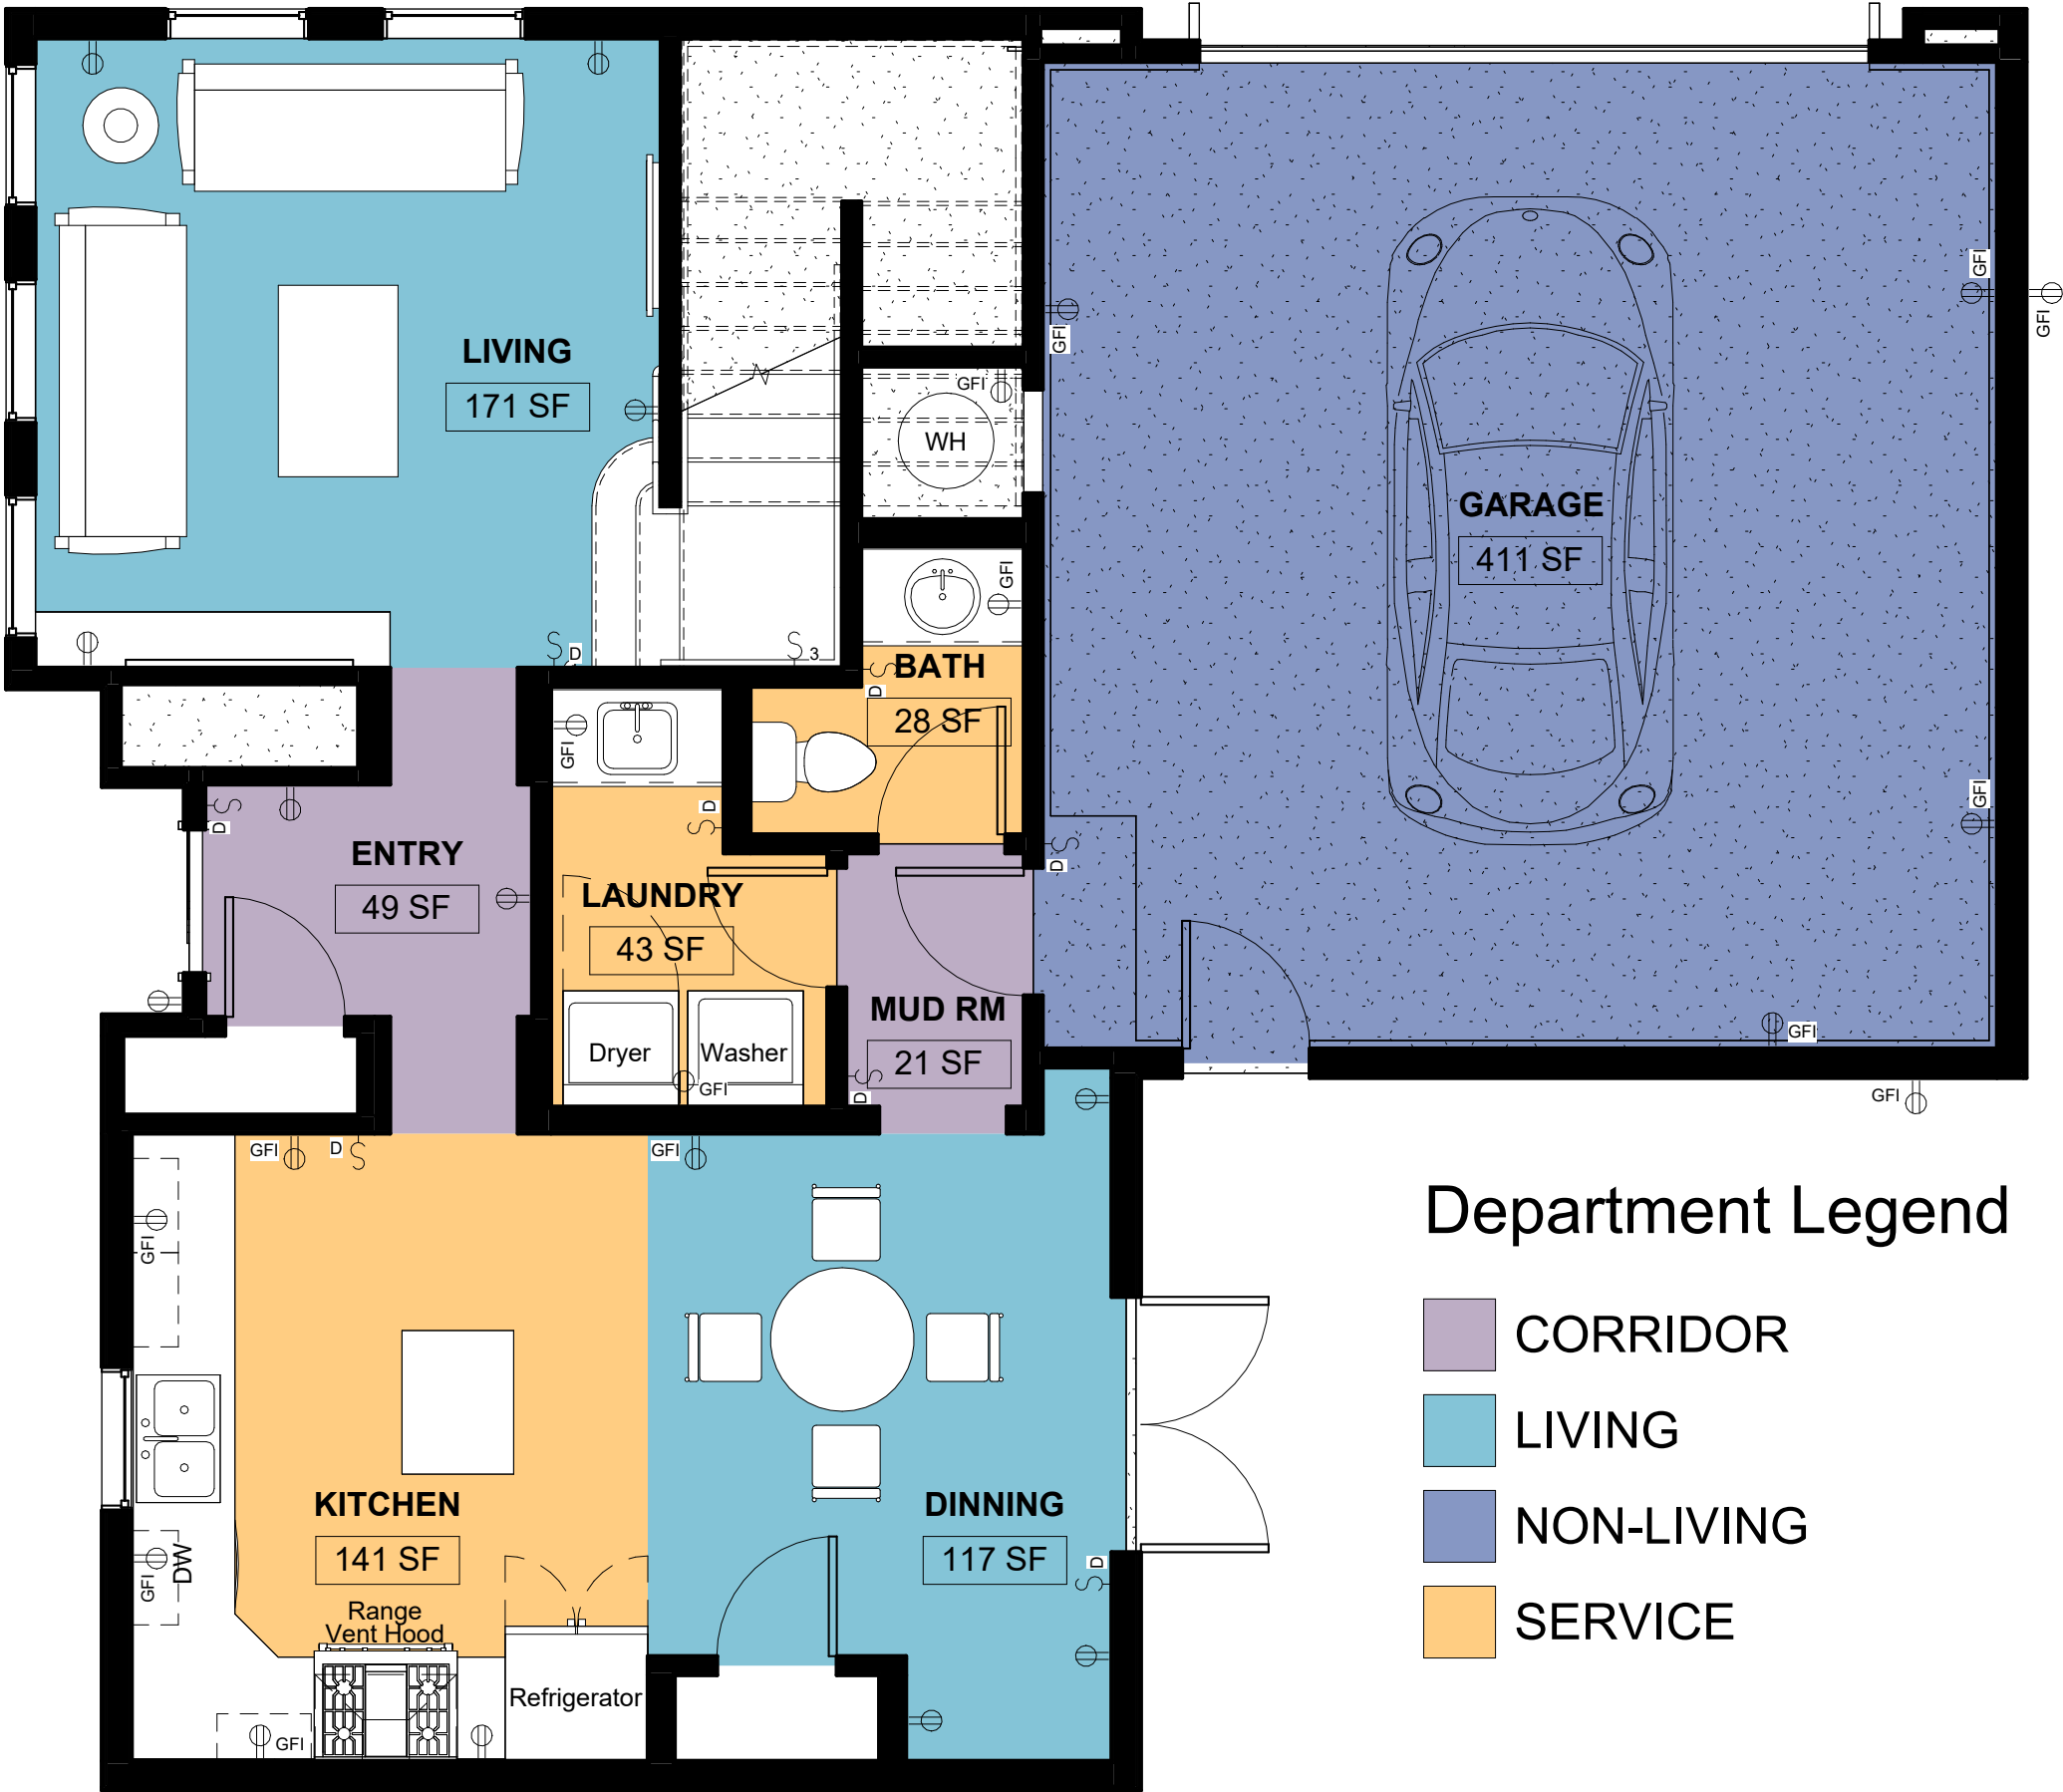

Department Legend

 - CORRIDOR
- LIVING
- NON-LIVING
- SERVICE



1 1st Floor Presentation Plan
1/4" = 1'-0"

Joshua Tio
ARCH 150 FINAL
PRESENTATION
PLAN LEVEL 1

Project number	EX03
Date	7-15-2026
Drawn by	Joshua Tio
Checked by	Checker

A2.3

1/4" = 1'-0"



Saddleback College

www.saddleback.edu

Consultant
Address
Address
Phone
Fax
e-mail

Consultant
Address
Address
Phone
Fax
e-mail

Consultant
Address
Address
Phone
Fax
e-mail

Consultant
Address
Address
Phone
Fax
e-mail

Consultant
Address
Address
Phone
Fax
e-mail


No.	Description	Date

Joshua Tio
ARCH 150 FINAL
PRESENTATION
PLAN LEVEL 2


Project number	EX03
Date	7-15-2026
Drawn by	Joshua Tio
Checked by	Checker

A2.4

1/4" = 1'-0"

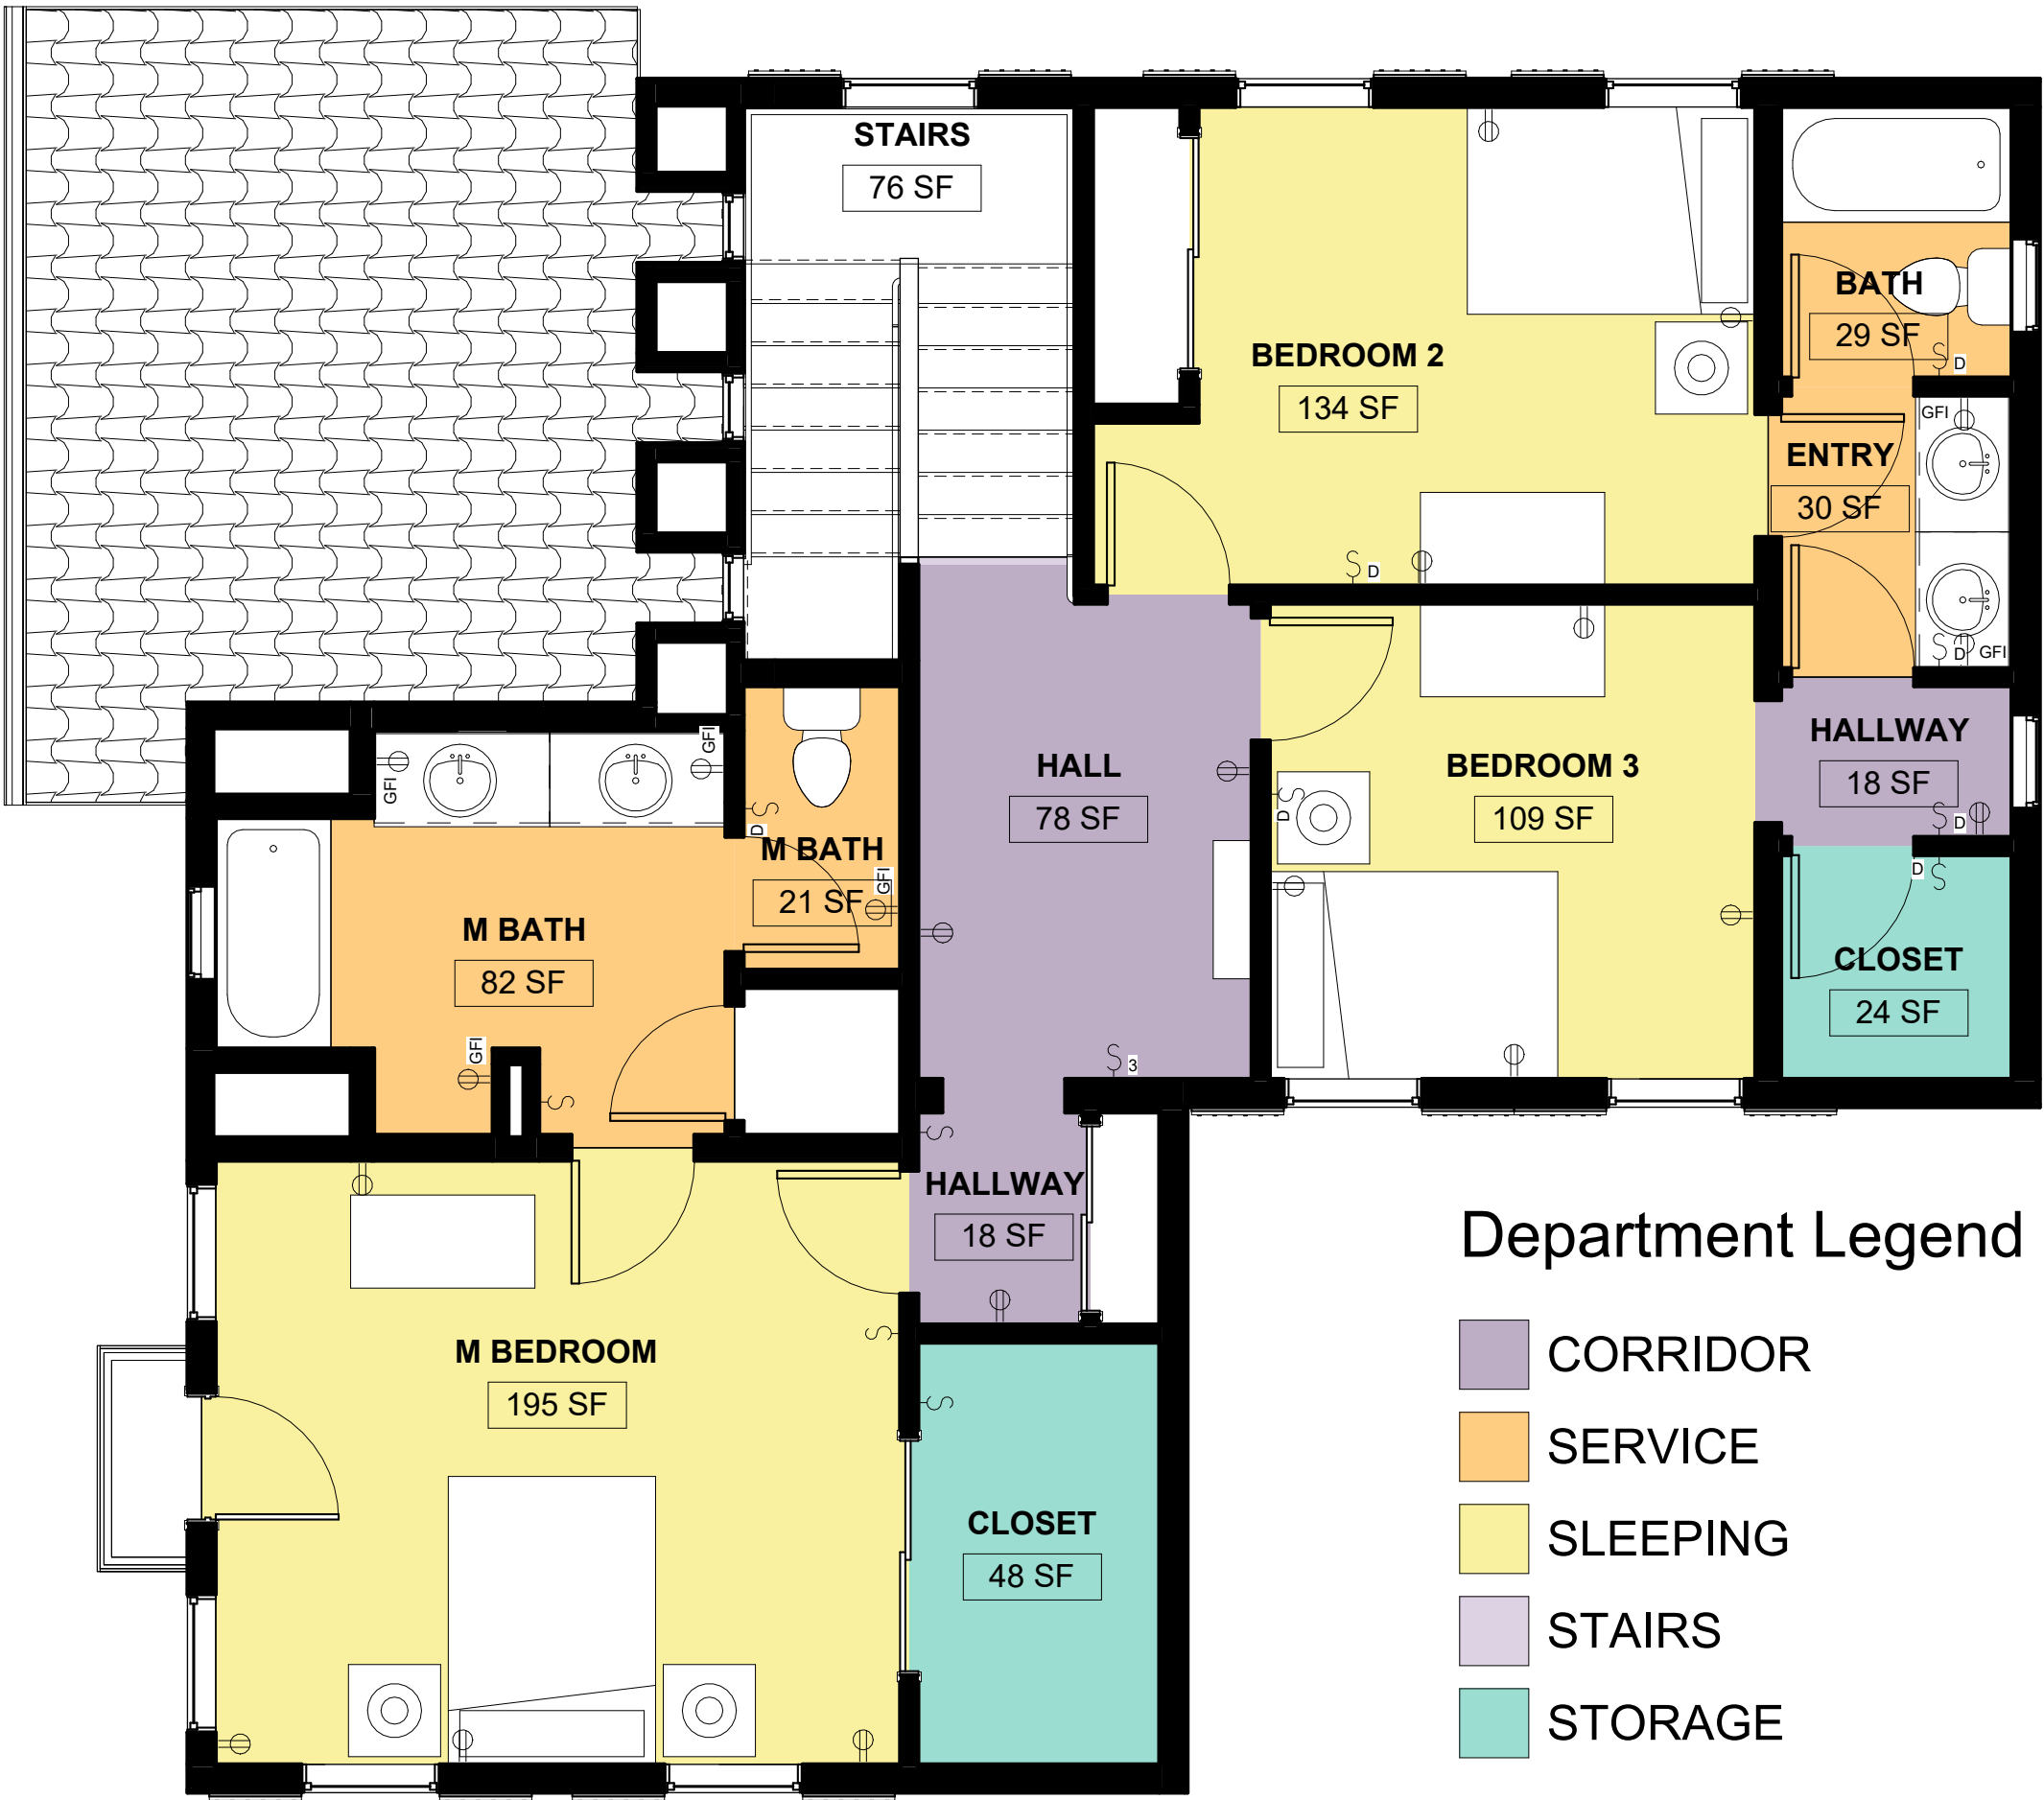

 1 2nd Floor Presentation Plan
1/4" = 1'-0"





Saddleback College

www.saddleback.edu

Consultant
Address
Address
Phone
Fax
e-mail

Consultant
Address
Address
Phone
Fax
e-mail

Consultant
Address
Address
Phone
Fax
e-mail

Consultant
Address
Address
Phone
Fax
e-mail

Consultant
Address
Address
Phone
Fax
e-mail


No.	Description	Date

Joshua Tio
ARCH 150 FINAL
FOUNDATION
PLAN

Project number	EX03
Date	7-15-2026
Drawn by	Joshua Tio
Checked by	Checker

A2.5

1/4" = 1'-0"

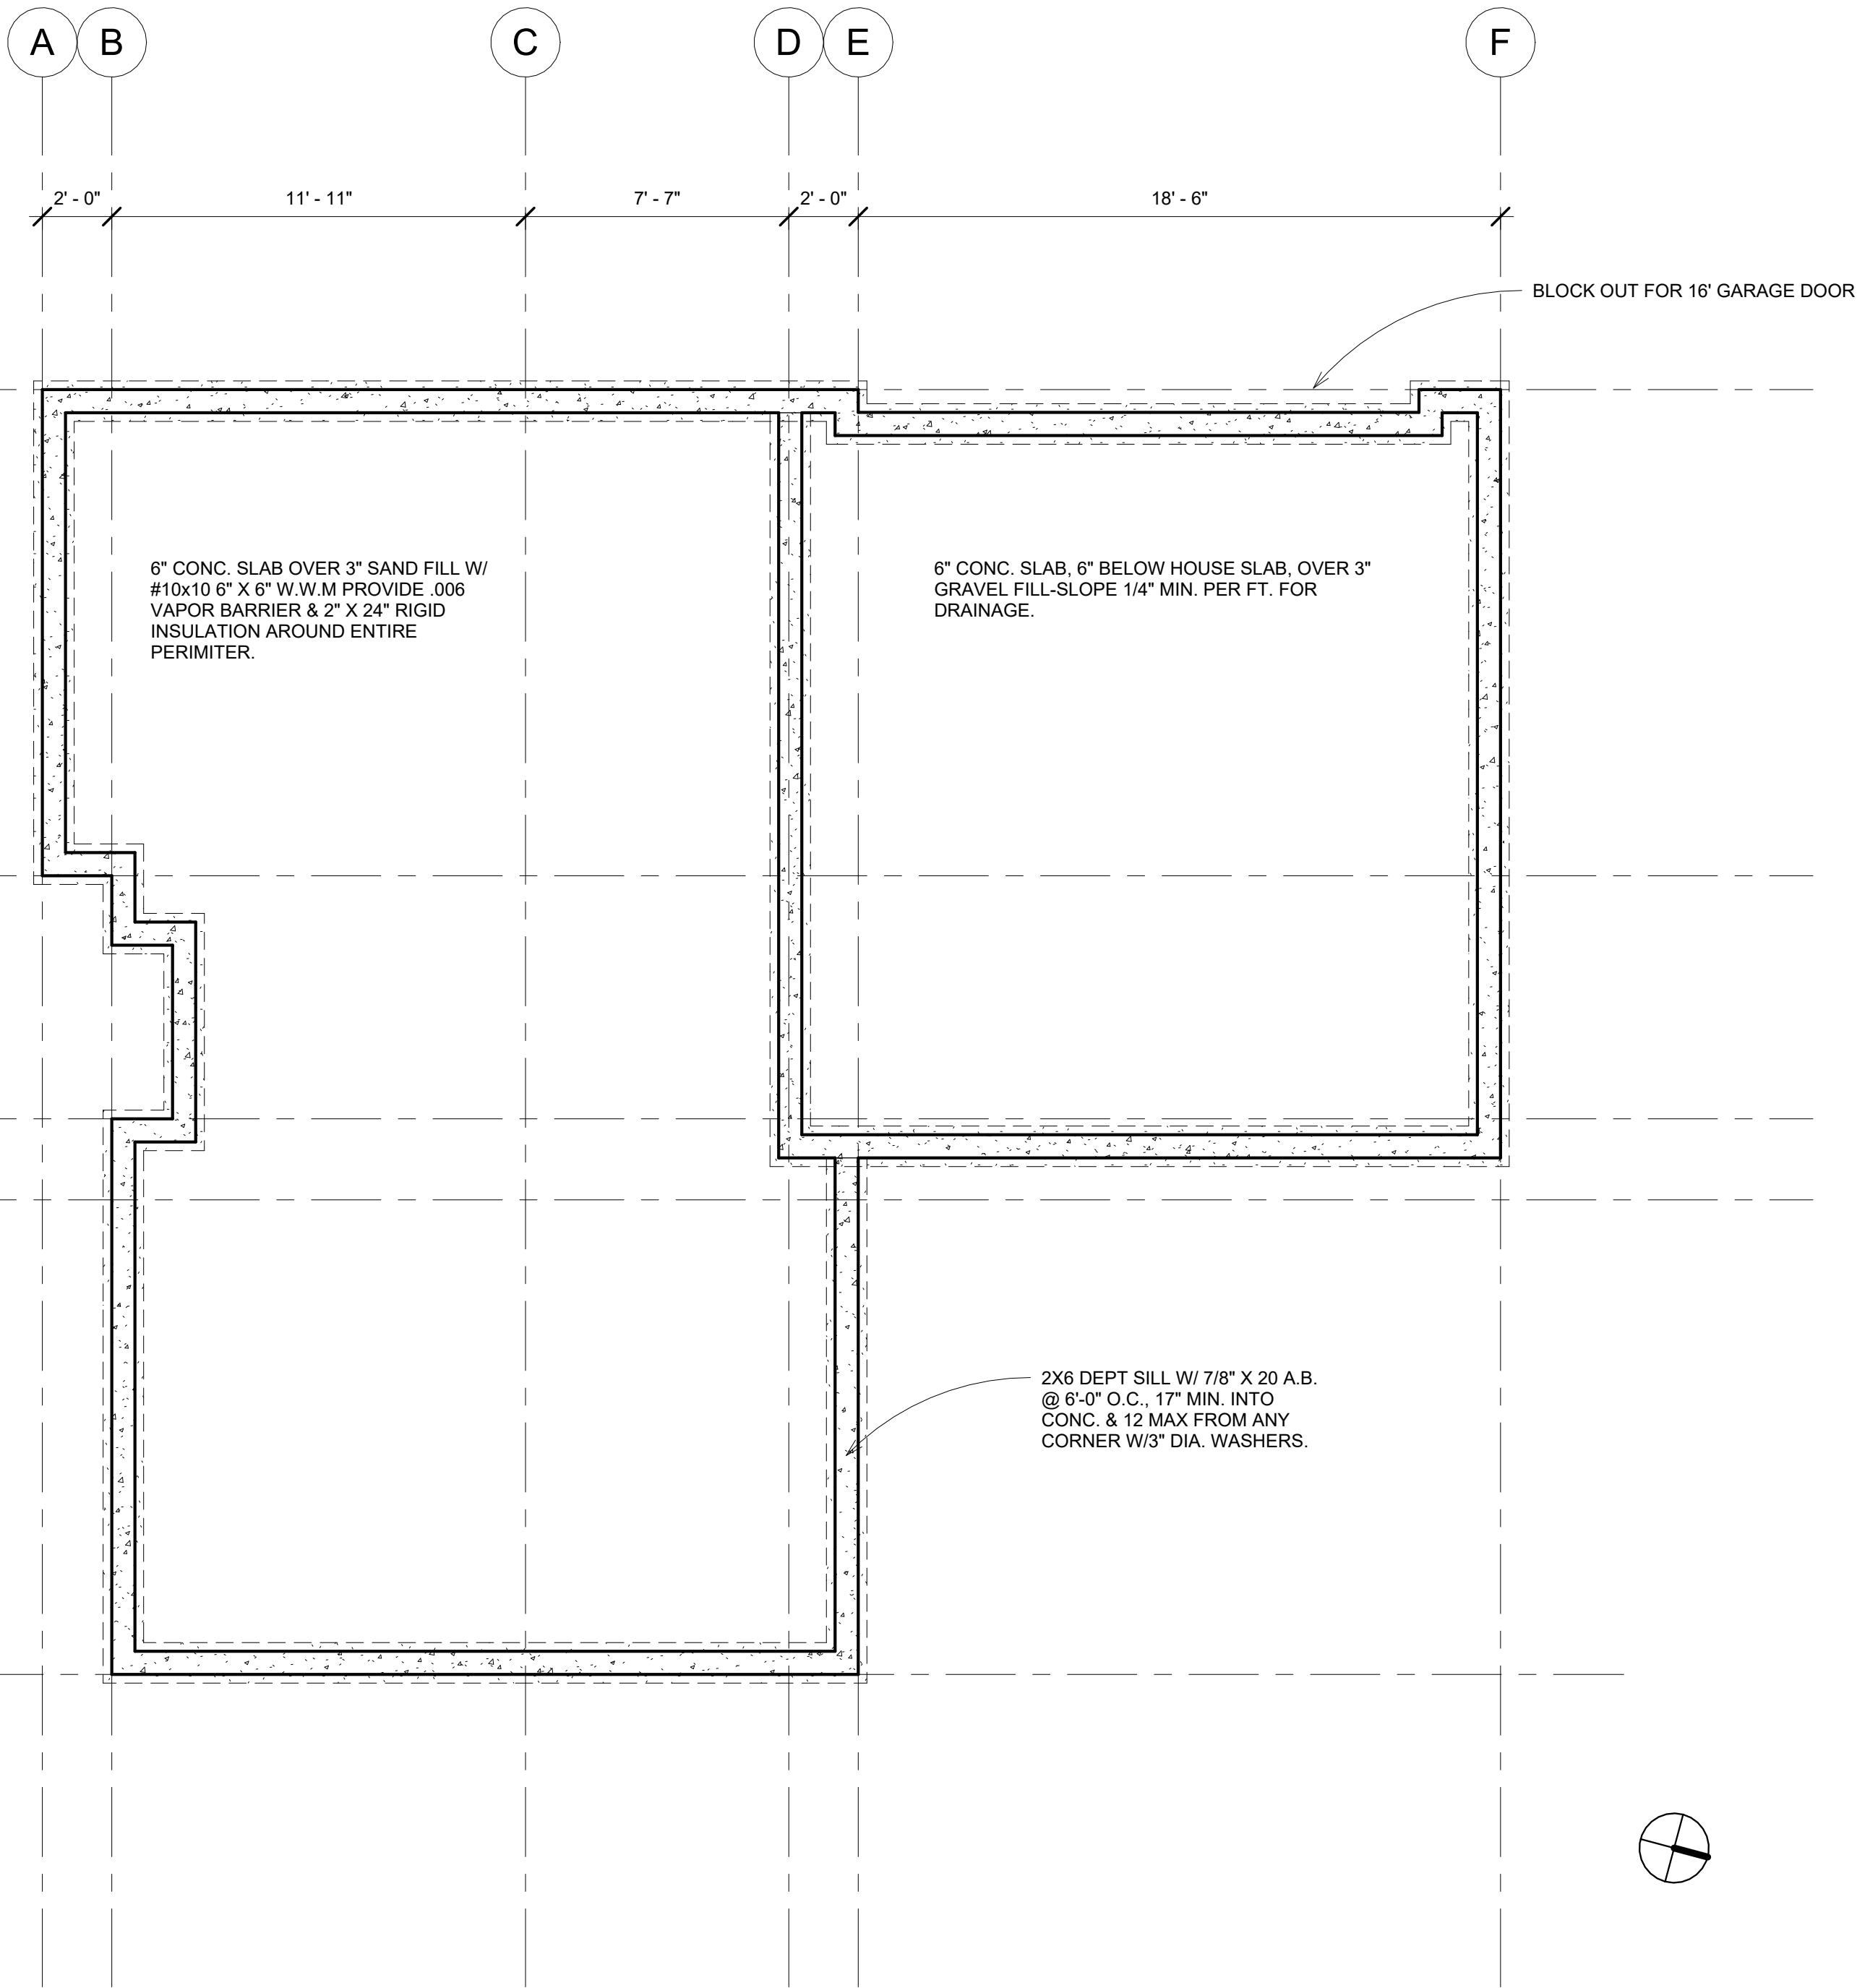



Saddleback College

www.saddleback.edu

Consultant
Address
Address
Phone
Fax
e-mail

Consultant
Address
Address
Phone
Fax
e-mail

Consultant
Address
Address
Phone
Fax
e-mail

Consultant
Address
Address
Phone
Fax
e-mail

Consultant
Address
Address
Phone
Fax
e-mail


No.	Description	Date

Joshua Tio
ARCH 150 FINAL
ELECTRICAL
PLAN LEVEL 1

Project number	EX03
Date	7-15-2026
Drawn by	Joshua Tio
Checked by	Checker

A2.6

1/4" = 1'-0"

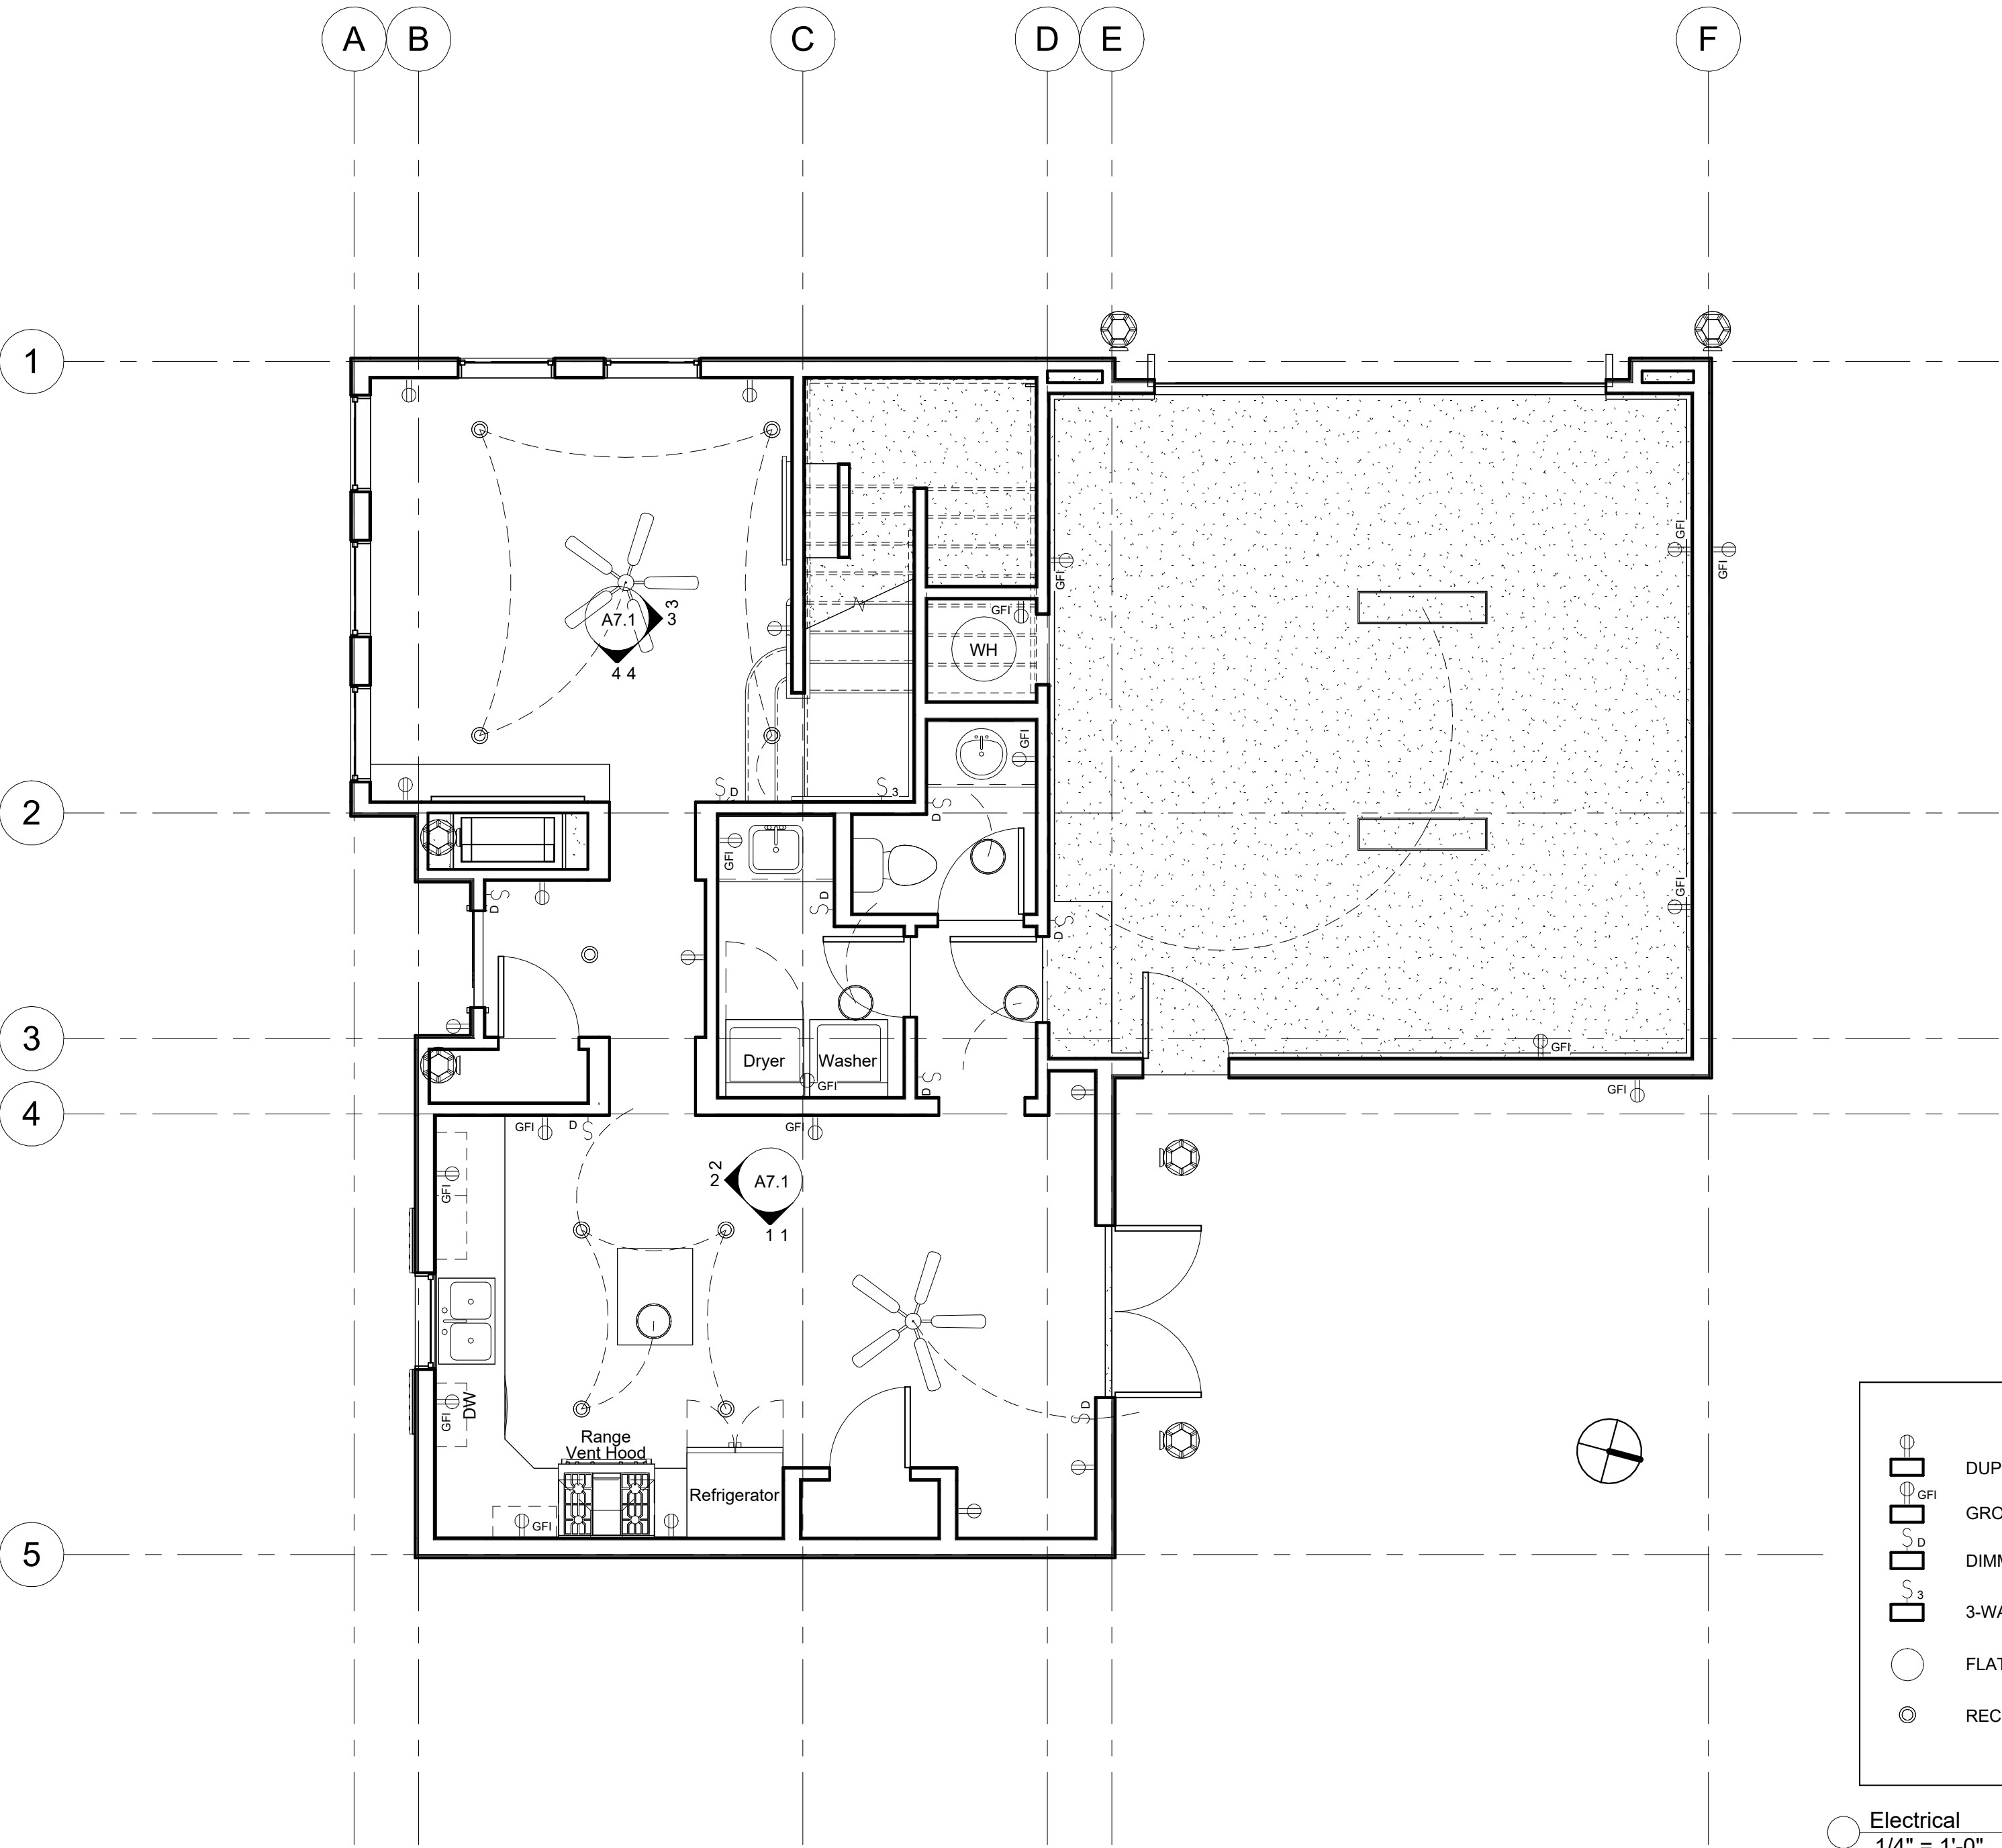

DUPLEX OUTLET

GROUND FAULT INTER

DIMMER SWITCH

3-WAY SWITCH

FLAT ROUND DWELLING LIGHT

RECESSED CAN LIGHT

Electrical
1/4" = 1'-0"



Saddleback College

www.saddleback.edu

Consultant
Address
Address
Phone
Fax
e-mail

Consultant
Address
Address
Phone
Fax
e-mail

Consultant
Address
Address
Phone
Fax
e-mail

Consultant
Address
Address
Phone
Fax
e-mail

Consultant
Address
Address
Phone
Fax
e-mail

No.	Description	Date

Joshua Tio
ARCH 150 FINAL
ELECTRICAL
PLAN LEVEL 2

Project number	EX03
Date	7-15-2026
Drawn by	Joshua Tio
Checked by	Checker

A2.7

1/4" = 1'-0"



- DUPLEX OUTLET
- GROUND FAULT INTER
- DIMMER SWITCH
- 3-WAY SWITCH
- FLAT ROUND DWELLING LIGHT
- RECESSED CAN LIGHT

Electrical
1/4" = 1'-0"



Saddleback College

www.saddleback.edu

Consultant
Address
Address
Phone
Fax
e-mail

Consultant
Address
Address
Phone
Fax
e-mail

Consultant
Address
Address
Phone
Fax
e-mail

Consultant
Address
Address
Phone
Fax
e-mail

Consultant
Address
Address
Phone
Fax
e-mail


No.	Description	Date

Joshua Tio
ARCH 150 FINAL
NORTH & SOUTH
ELEVATION

Project number	EX03
Date	7-15-2026
Drawn by	Joshua Tio
Checked by	Checker

A3.1

3/16" = 1'-0"

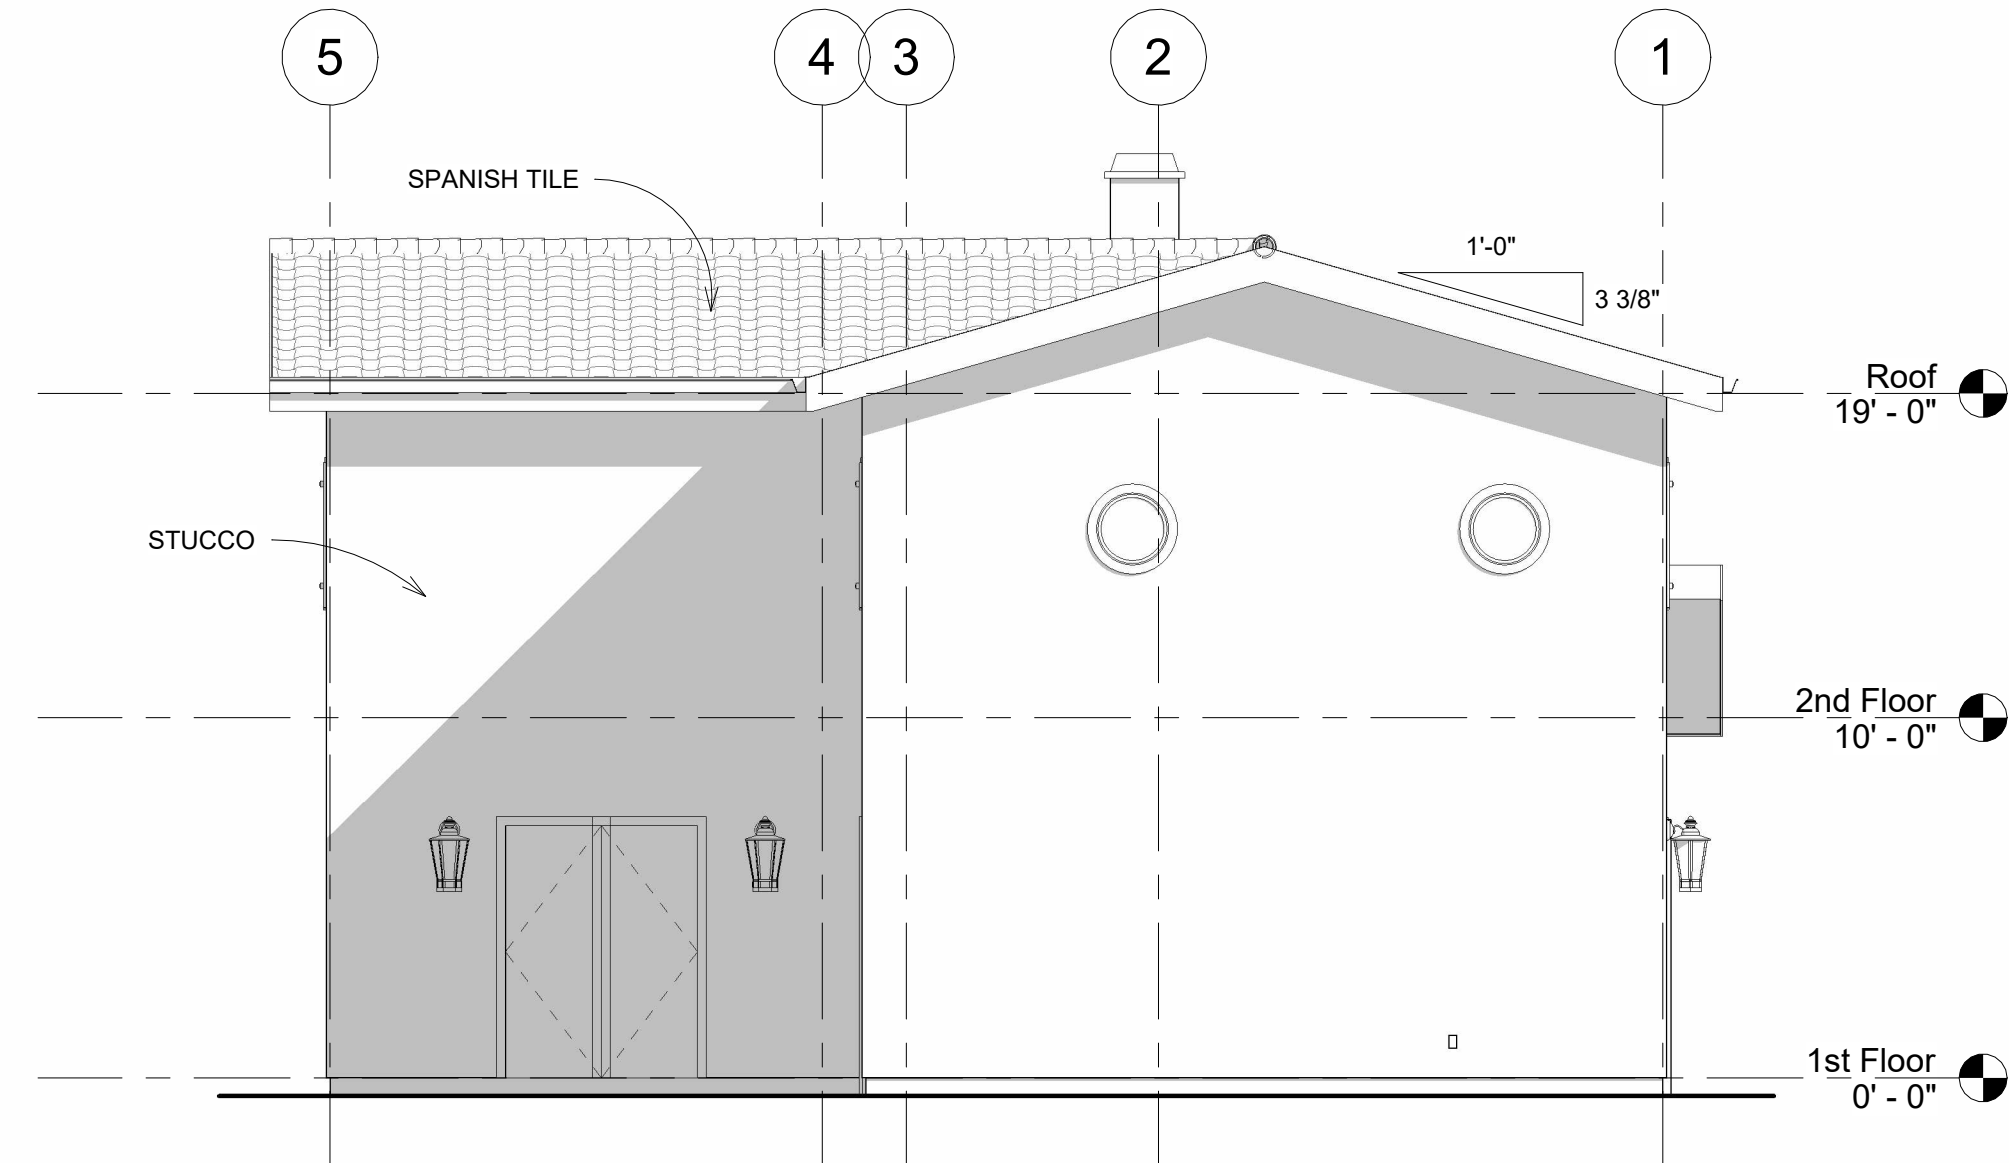

① North
3/16" = 1'-0"



② South
3/16" = 1'-0"



Saddleback College

www.saddleback.edu

Consultant
Address
Address
Phone
Fax
e-mail

Consultant
Address
Address
Phone
Fax
e-mail

Consultant
Address
Address
Phone
Fax
e-mail

Consultant
Address
Address
Phone
Fax
e-mail

Consultant
Address
Address
Phone
Fax
e-mail


No.	Description	Date

Joshua Tio
ARCH 150 FINAL
EAST & WEST
ELEVATION


Project number	EX03
Date	7-15-2026
Drawn by	Joshua Tio
Checked by	Checker

A3.2

3/16" = 1'-0"

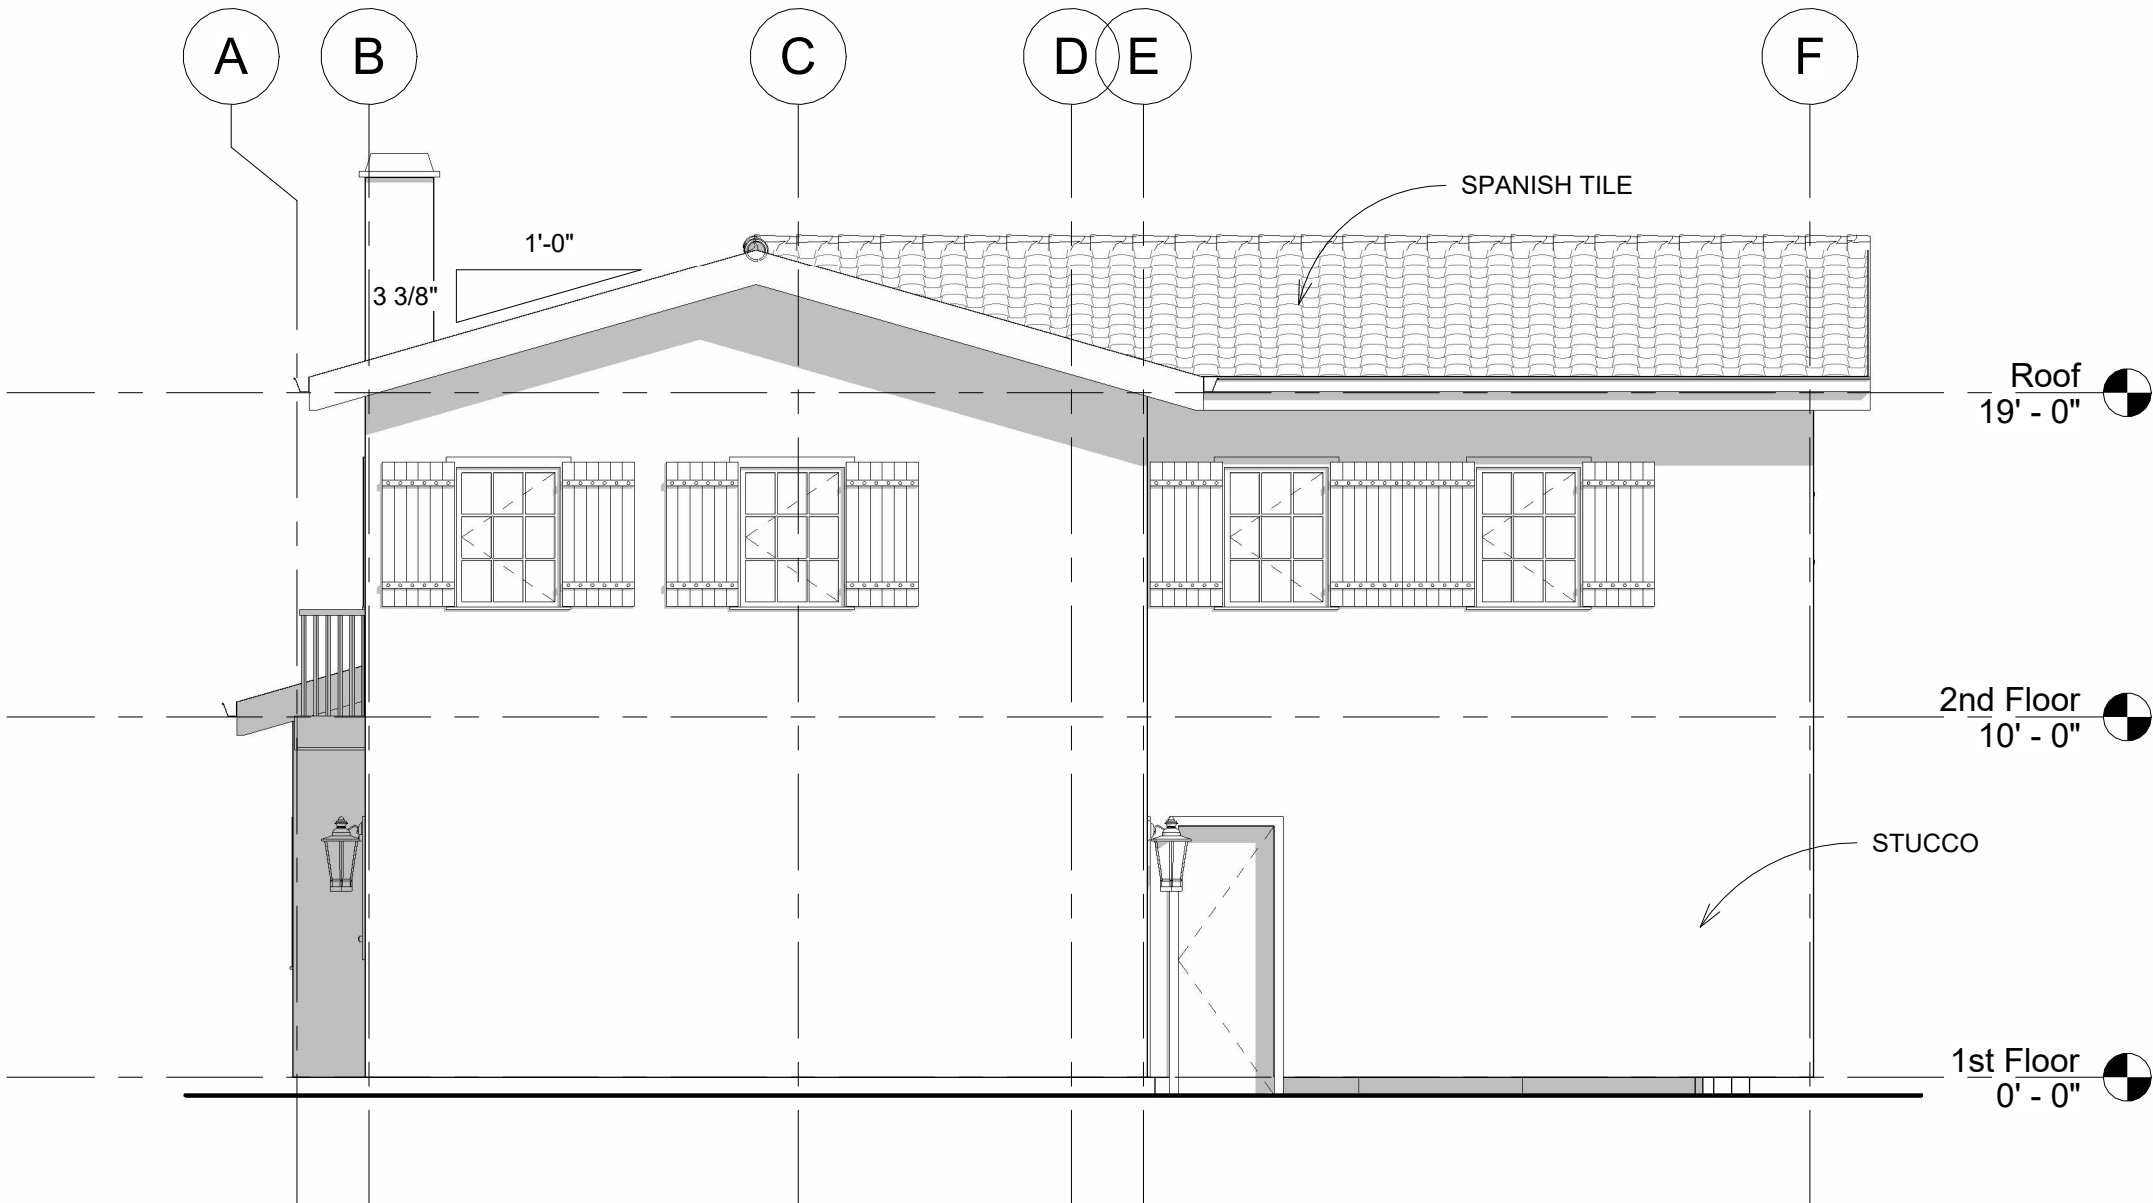

1 East
3/16" = 1'-0"

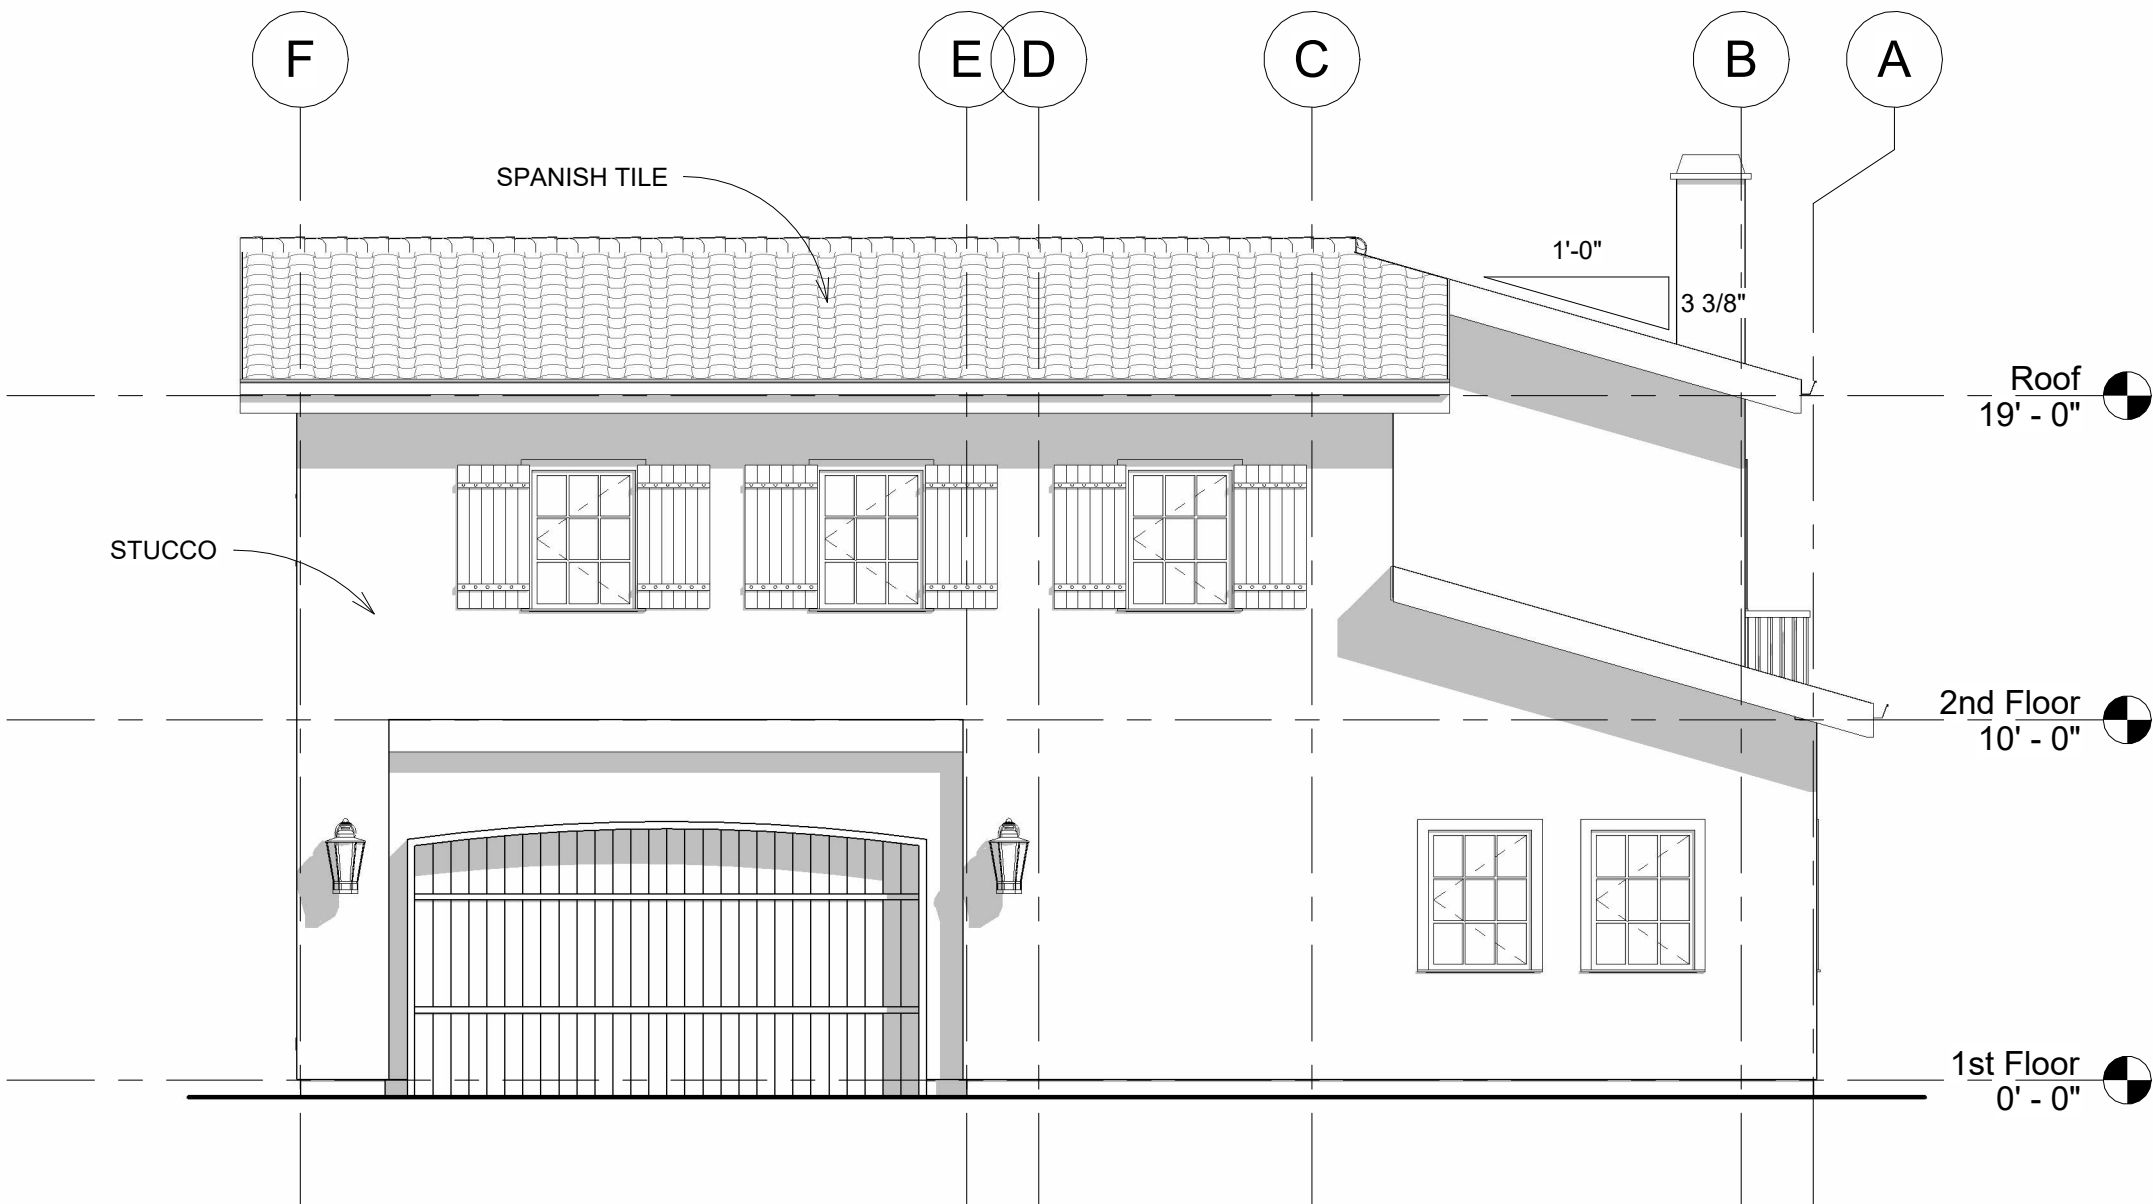

2 West
3/16" = 1'-0"



Saddleback College

www.saddleback.edu

Consultant
Address
Address
Phone
Fax
e-mail

Consultant
Address
Address
Phone
Fax
e-mail

Consultant
Address
Address
Phone
Fax
e-mail

Consultant
Address
Address
Phone
Fax
e-mail

Consultant
Address
Address
Phone
Fax
e-mail


No.	Description	Date

Joshua Tio
ARCH 150 FINAL
BUILDING
SECTION 1

Project number	EX03
Date	7-15-2026
Drawn by	Joshua Tio
Checked by	Checker

A4.1

1/4" = 1'-0"

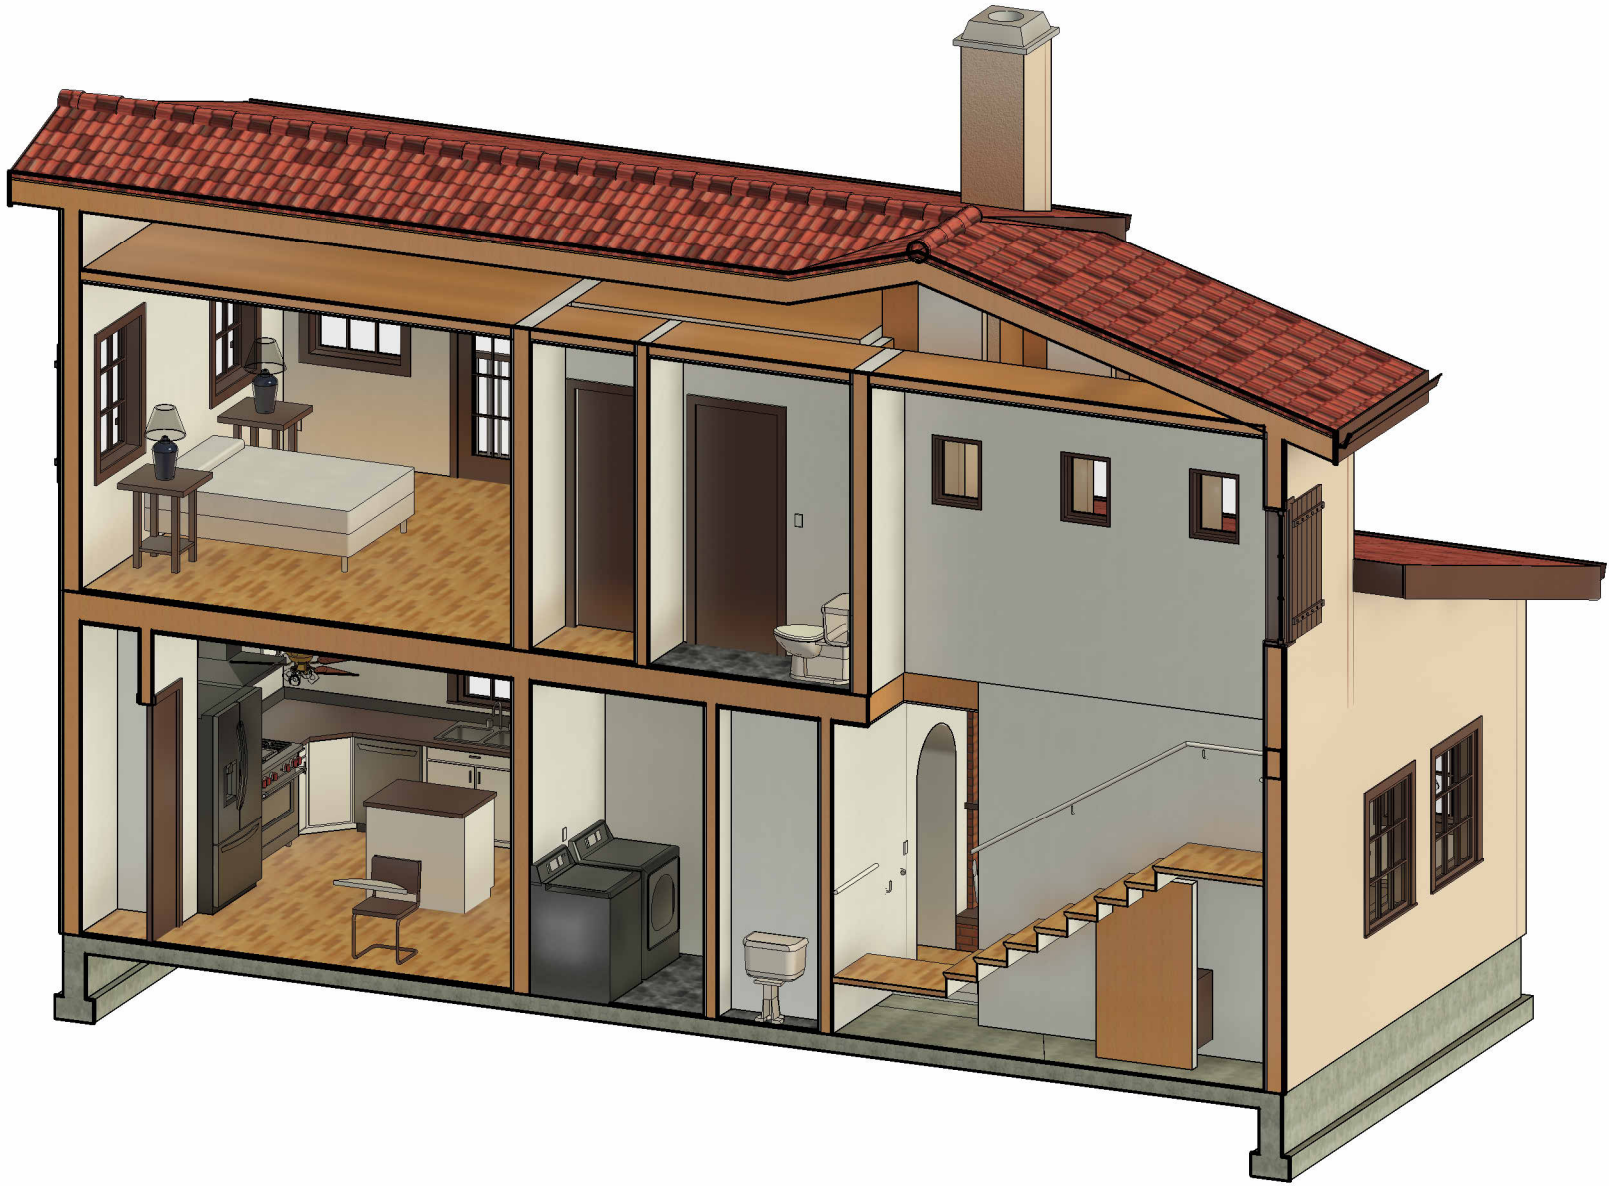

2 3D Section 1



1 Section 1
1/4" = 1'-0"



Saddleback College

www.saddleback.edu

Consultant
Address
Address
Phone
Fax
e-mail

Consultant
Address
Address
Phone
Fax
e-mail

Consultant
Address
Address
Phone
Fax
e-mail

Consultant
Address
Address
Phone
Fax
e-mail

Consultant
Address
Address
Phone
Fax
e-mail


No.	Description	Date

Joshua Tio
ARCH 150 FINAL
BUILDING
SECTION 2


Project number	EX03
Date	7-15-2026
Drawn by	Joshua Tio
Checked by	Checker

A4.2

1/4" = 1'-0"

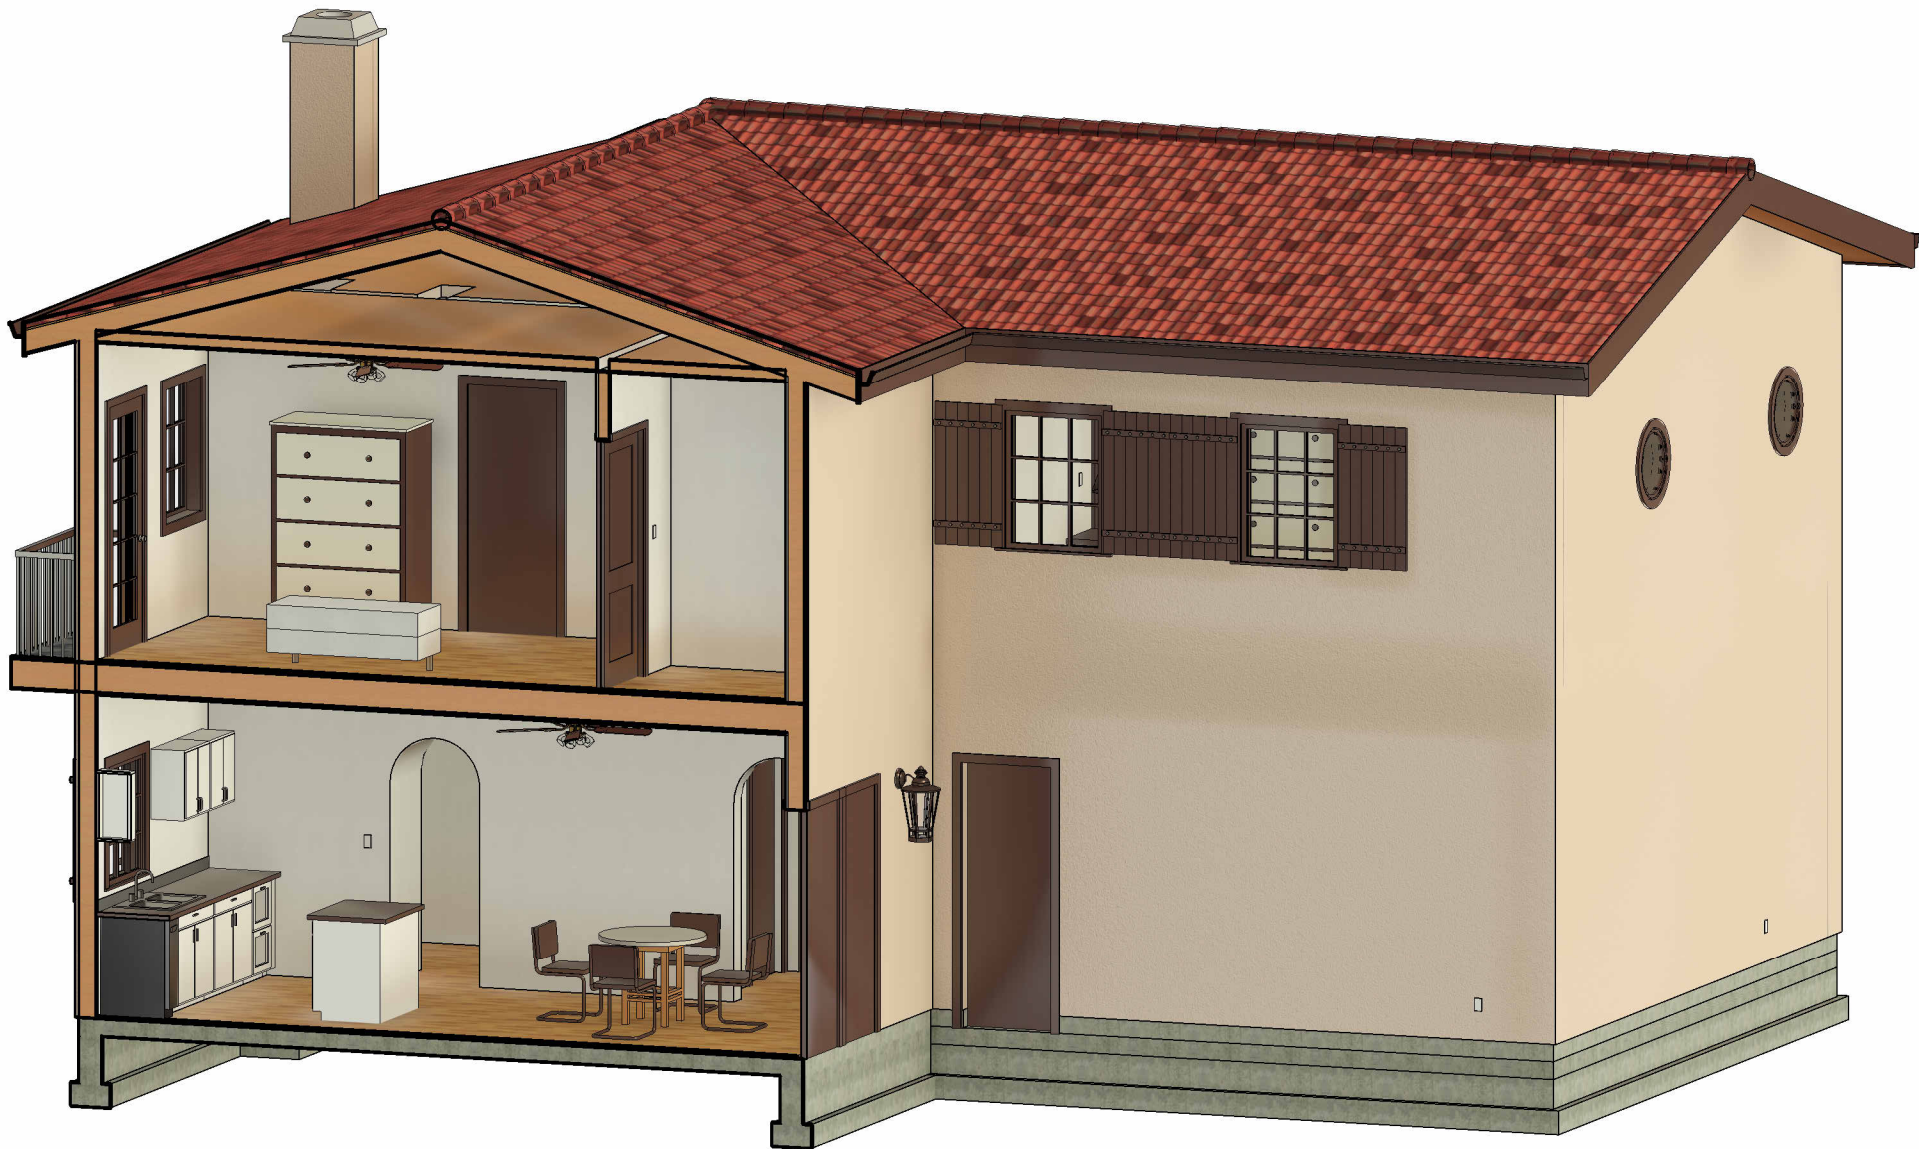

2 3D Section 2

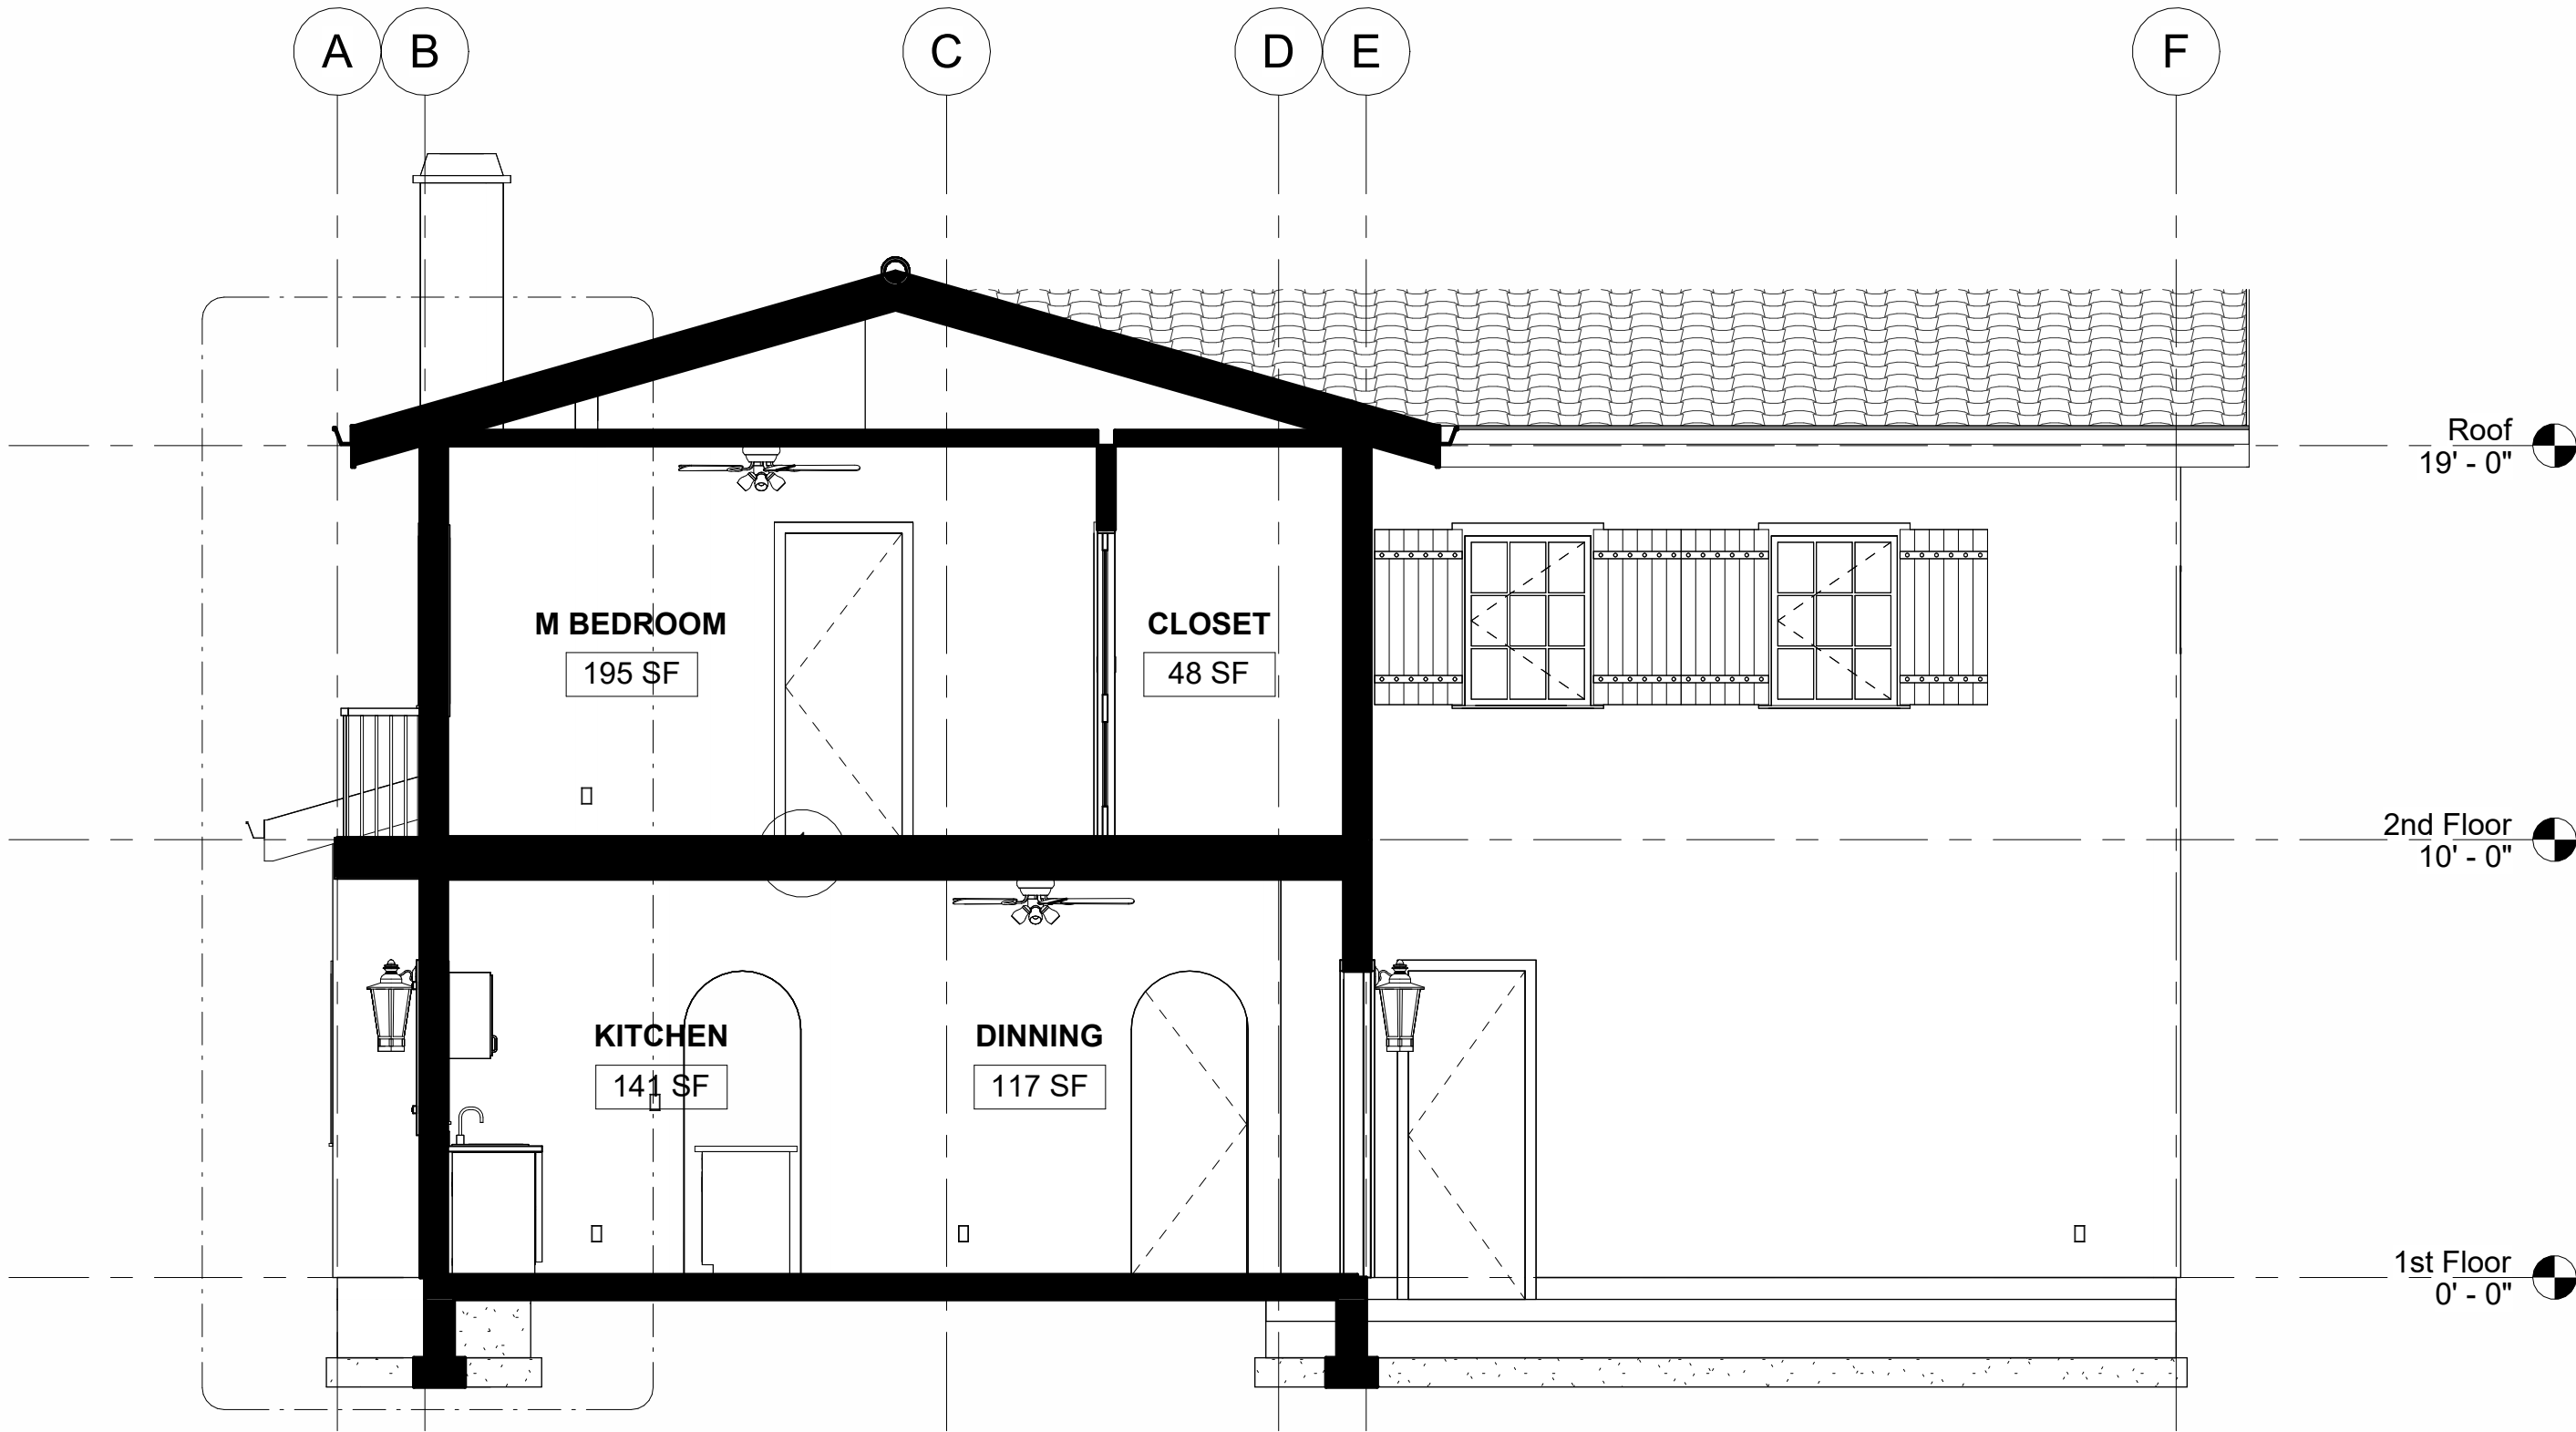

1 Section 2
1/4" = 1'-0"



Saddleback College

www.saddleback.edu

Consultant
Address
Address
Phone
Fax
e-mail

Consultant
Address
Address
Phone
Fax
e-mail

Consultant
Address
Address
Phone
Fax
e-mail

Consultant
Address
Address
Phone
Fax
e-mail

Consultant
Address
Address
Phone
Fax
e-mail



No.	Description	Date

Joshua Tio
ARCH 150 FINAL
WALL SECTIONS

Project number	EX03
Date	7-15-2026
Drawn by	Joshua Tio
Checked by	Checker

A4.3

1/2" = 1'-0"

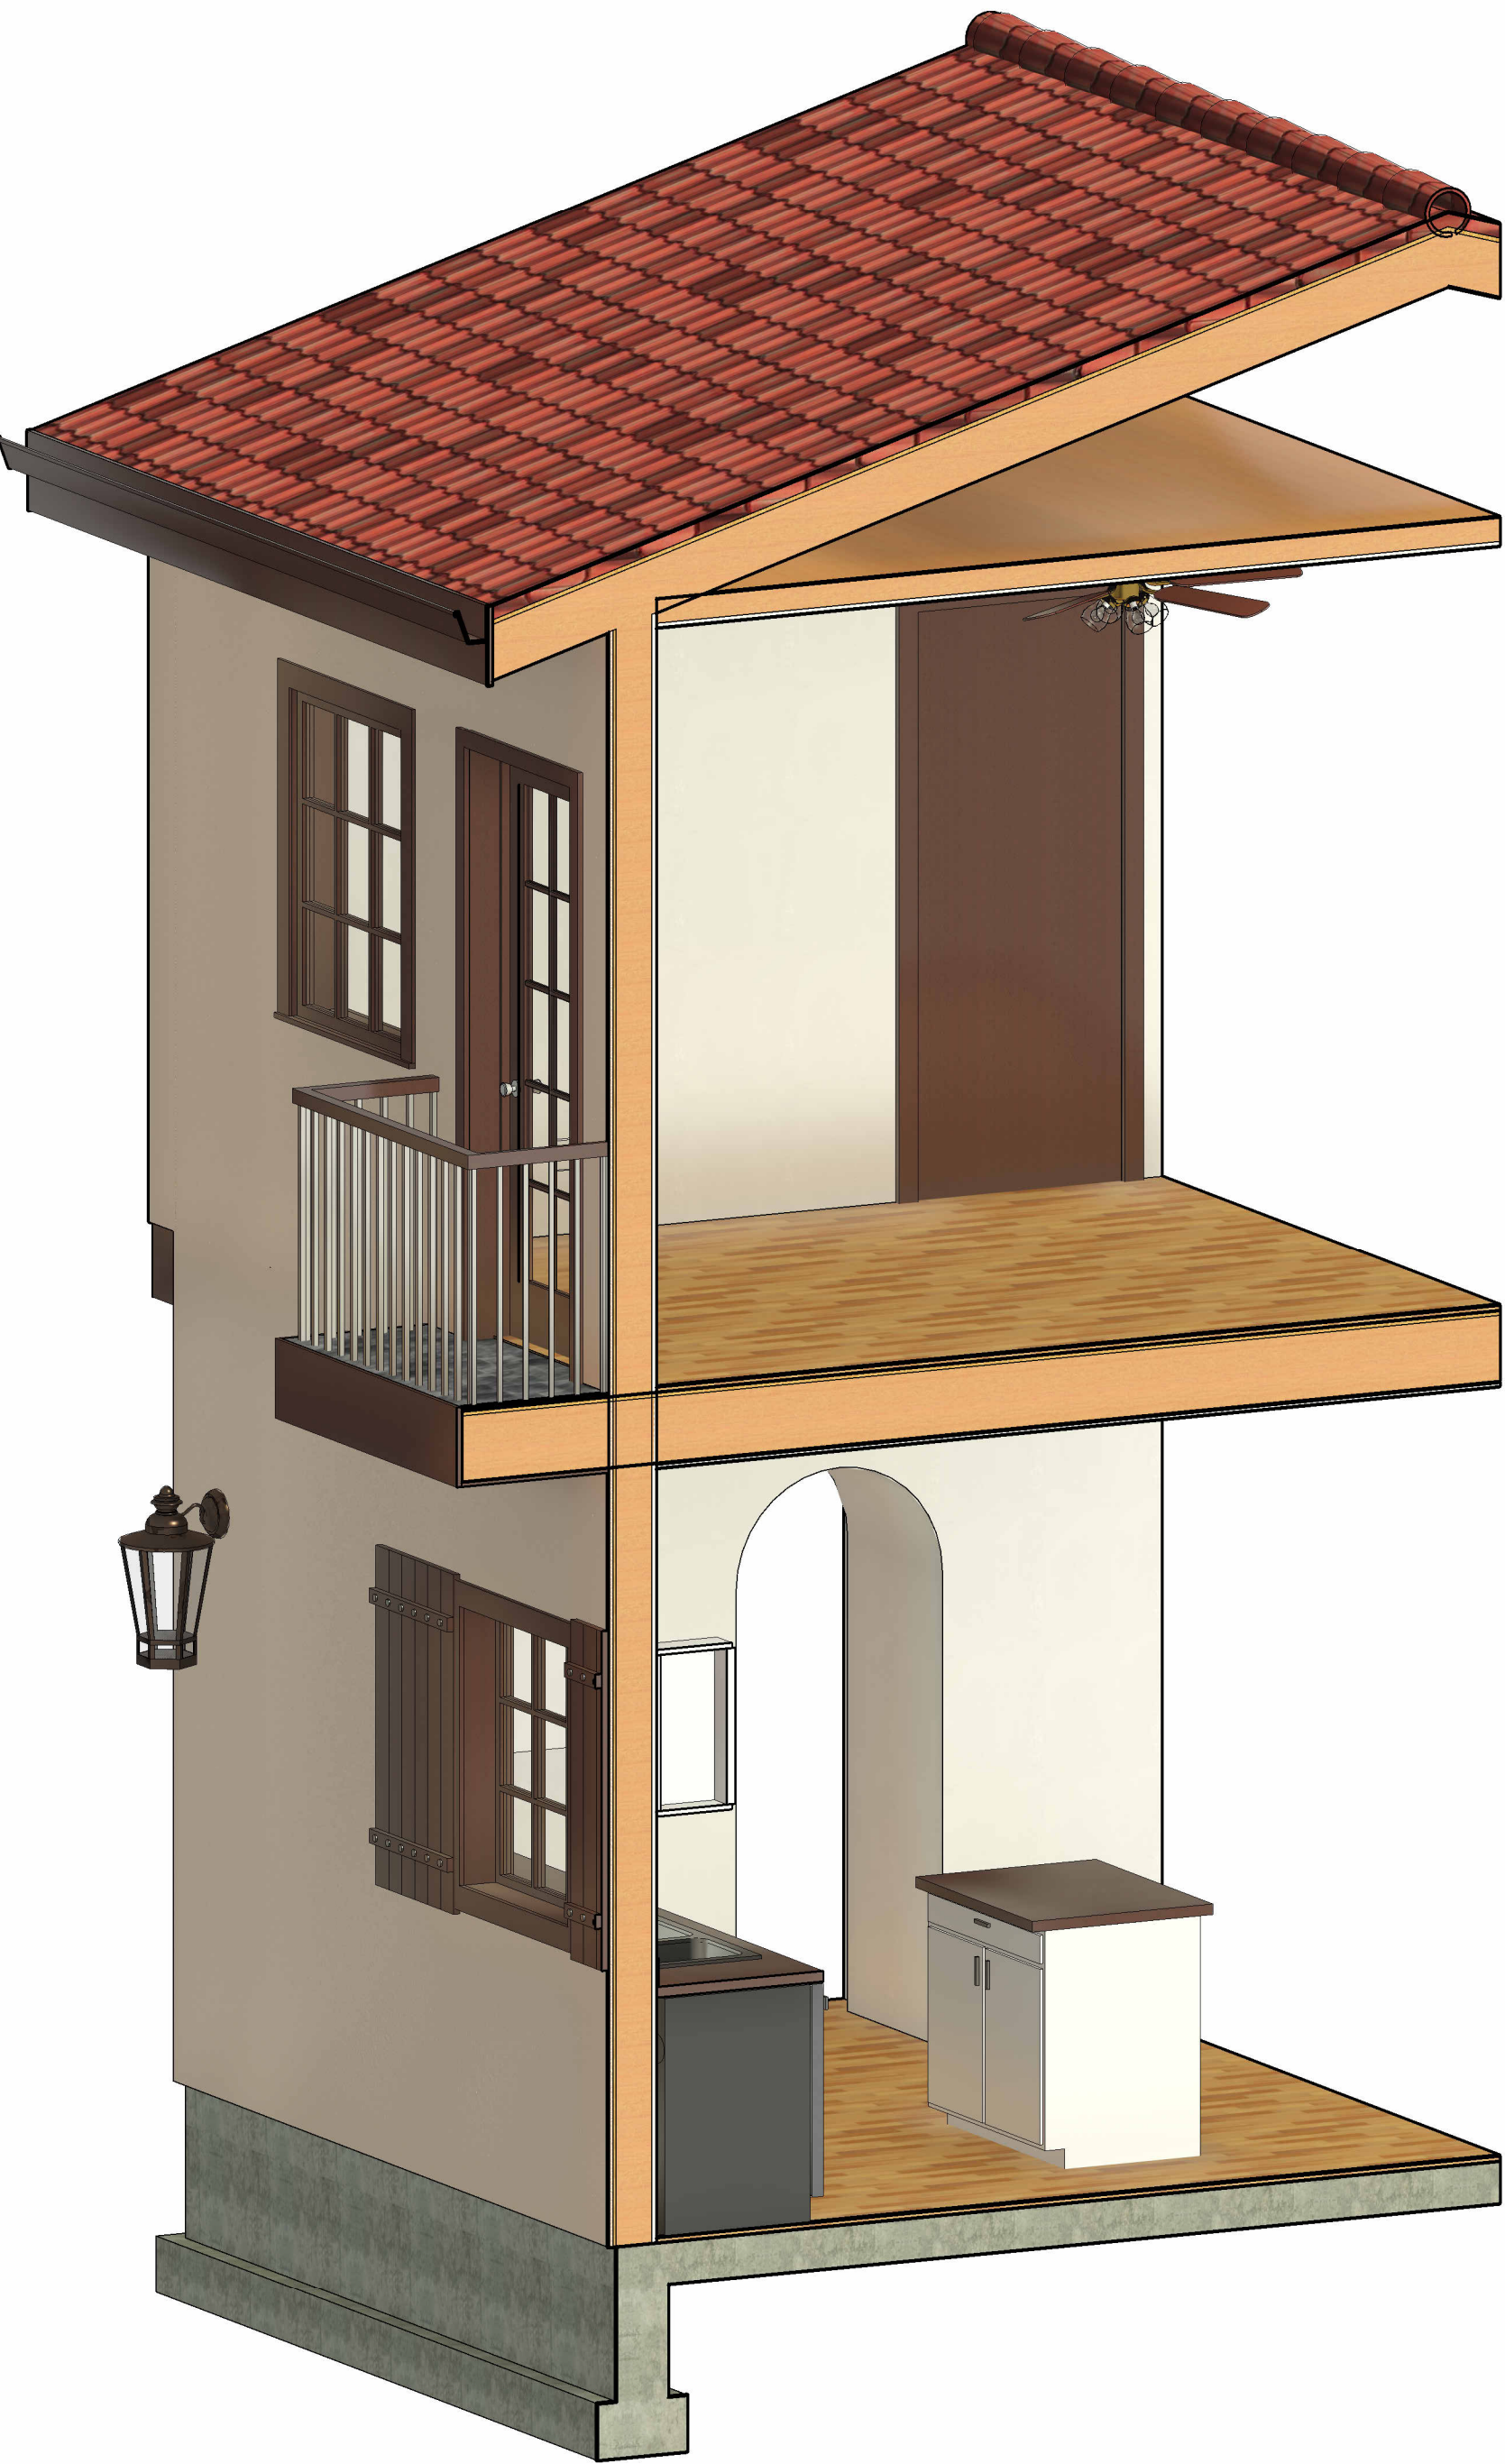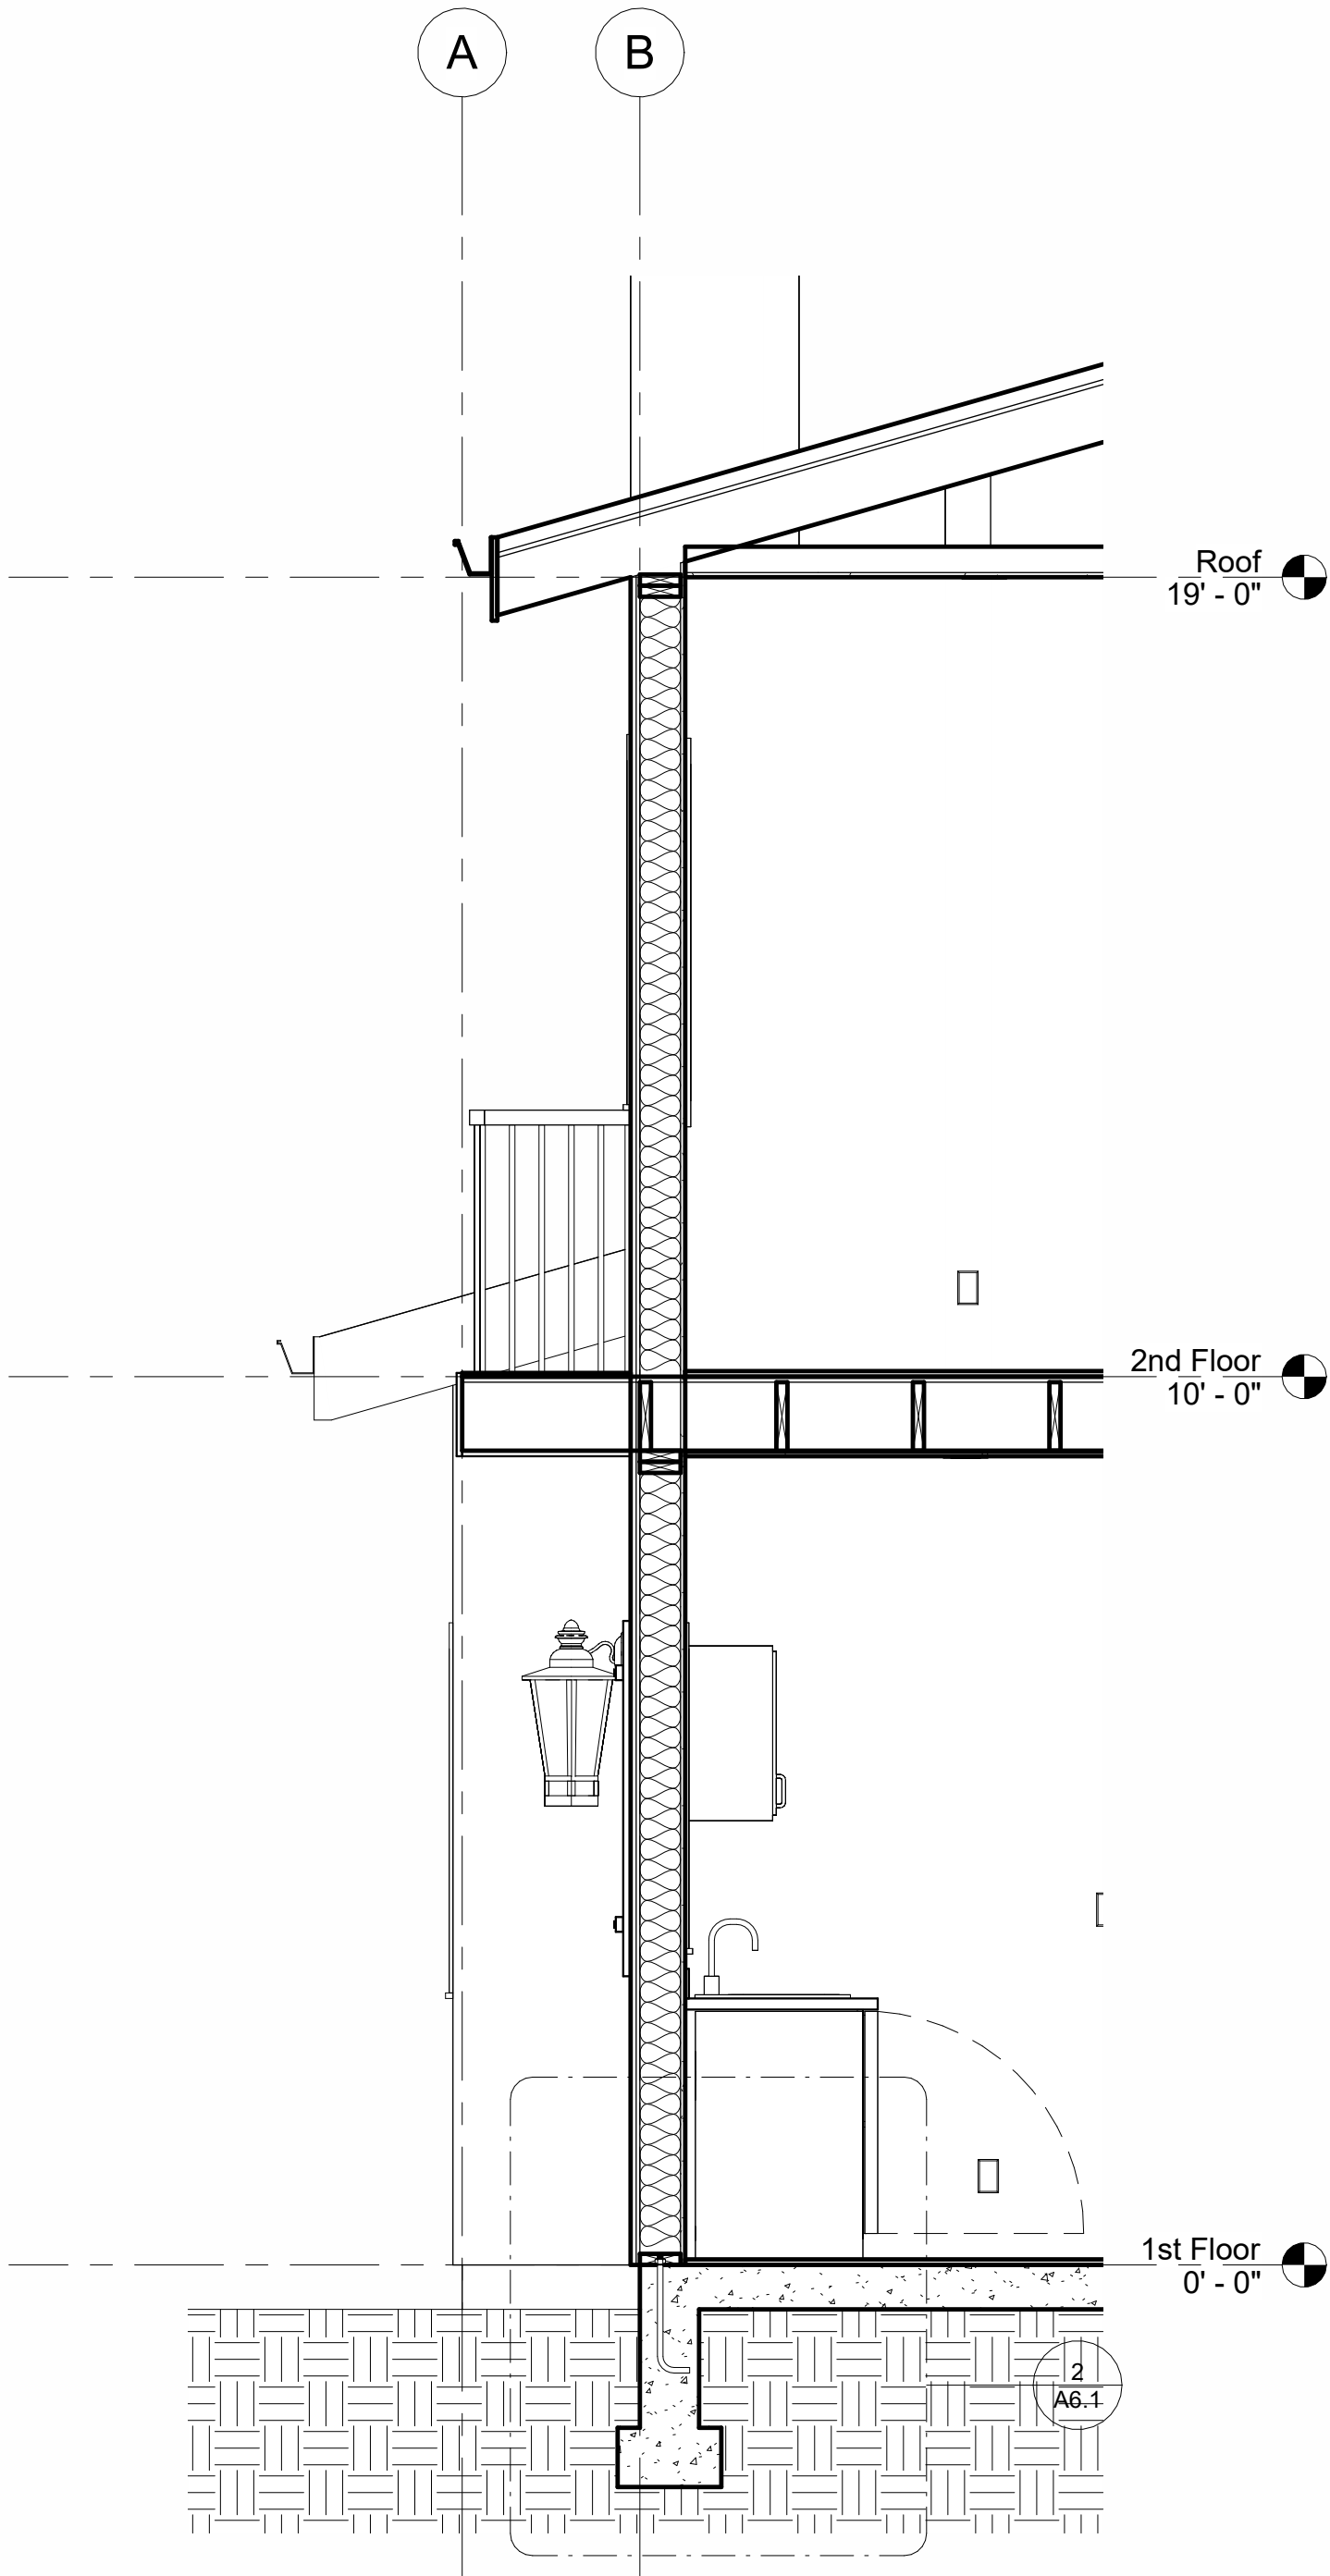

2 3D Wall Cutout



Saddleback College

www.saddleback.edu

Consultant
Address
Address
Phone
Fax
e-mail

Consultant
Address
Address
Phone
Fax
e-mail

Consultant
Address
Address
Phone
Fax
e-mail

Consultant
Address
Address
Phone
Fax
e-mail

Consultant
Address
Address
Phone
Fax
e-mail

No.	Description	Date

Joshua Tio

ARCH 150 FINAL

SCHEDULES

Project number	EX03
Date	7-15-2026
Drawn by	Joshua Tio
Checked by	Checker

A5.1

Door Schedule							
Count	Door #	Door Style	Head Height	Height	Level	Thickness	Width
3	<varies>	Door-Interior-Double-Sliding-2_Panel-Wood	7' - 0"	7' - 0"	2nd Floor	0' - 1 3/8"	<varies>
1	31	Door-Interior-Single-Full-Glass-Wood	7' - 0"	7' - 0"	2nd Floor	0' - 1 3/8"	2' - 8"
18	<varies>	Single-Flush	7' - 0"	<varies>	<varies>	0' - 2"	<varies>
1	6	Spanish Door	7' - 0"	7' - 0"	1st Floor		3' - 0"
1	3	Spanish Garage Door	6' - 6"	6' - 6"	1st Floor		14' - 0"

Window Schedule					
Count	Mark	Family	Head Height	Level	Width
1	8	Casement Window	7' - 0"	1st Floor	3' - 0"
1	9	Casement Window	7' - 0"	1st Floor	3' - 0"
1	10	Casement Window	7' - 0"	1st Floor	3' - 0"
1	11	Casement Window	7' - 0"	1st Floor	3' - 0"
1	12	Casement Window	7' - 0"	1st Floor	3' - 0"
1	13	Casement Window	7' - 0"	1st Floor	3' - 0"
1	14	Casement Window	7' - 0"	2nd Floor	3' - 0"
1	15	Casement Window	7' - 0"	2nd Floor	3' - 0"
1	16	Casement Window	7' - 0"	2nd Floor	3' - 0"
1	17	Casement Window	7' - 0"	2nd Floor	3' - 0"
1	18	Casement Window	7' - 0"	2nd Floor	3' - 0"
1	19	Casement Window	7' - 0"	2nd Floor	3' - 0"
1	21	Casement Window	7' - 0"	2nd Floor	3' - 0"
1	24	Casement Window	7' - 0"	2nd Floor	3' - 0"
1	33	Casement Window	7' - 0"	2nd Floor	3' - 0"
1	27	Fixed	7' - 0"	2nd Floor	1' - 6"
1	28	Fixed	7' - 0"	2nd Floor	1' - 6"
1	29	Fixed	7' - 0"	2nd Floor	1' - 6"
1	30	Window-Fixed-Round	6' - 3"	2nd Floor	2' - 0"
1	31	Window-Fixed-Round	6' - 3"	2nd Floor	2' - 0"
1	32	Window-Fixed-Round	6' - 3"	2nd Floor	2' - 0"

Room Schedule			
Area	Level	Department	Name
141 SF	1st Floor	SERVICE	KITCHEN
117 SF	1st Floor	LIVING	DINNING
21 SF	1st Floor	CORRIDOR	MUD RM
43 SF	1st Floor	SERVICE	LAUNDRY
28 SF	1st Floor	SERVICE	BATH
49 SF	1st Floor	CORRIDOR	ENTRY
171 SF	1st Floor	LIVING	LIVING
411 SF	1st Floor	NON-LIVING	GARAGE
195 SF	2nd Floor	SLEEPING	M BEDROOM
48 SF	2nd Floor	STORAGE	CLOSET
82 SF	2nd Floor	SERVICE	M BATH
21 SF	2nd Floor	SERVICE	M BATH
24 SF	2nd Floor	STORAGE	CLOSET
134 SF	2nd Floor	SLEEPING	BEDROOM 2
29 SF	2nd Floor	SERVICE	BATH
30 SF	2nd Floor	SERVICE	ENTRY
18 SF	2nd Floor	CORRIDOR	HALLWAY
18 SF	2nd Floor	CORRIDOR	HALLWAY
109 SF	2nd Floor	SLEEPING	BEDROOM 3
76 SF	2nd Floor	STAIRS	STAIRS
78 SF	2nd Floor	CORRIDOR	HALL



Saddleback College

www.saddleback.edu

Consultant
Address
Address
Phone
Fax
e-mail

Consultant
Address
Address
Phone
Fax
e-mail

Consultant
Address
Address
Phone
Fax
e-mail

Consultant
Address
Address
Phone
Fax
e-mail

Consultant
Address
Address
Phone
Fax
e-mail


No.	Description	Date

Joshua Tio
ARCH 150 FINAL
DETAILS


Project number	EX03
Date	7-15-2026
Drawn by	Joshua Tio
Checked by	Checker

A6.1



As indicated

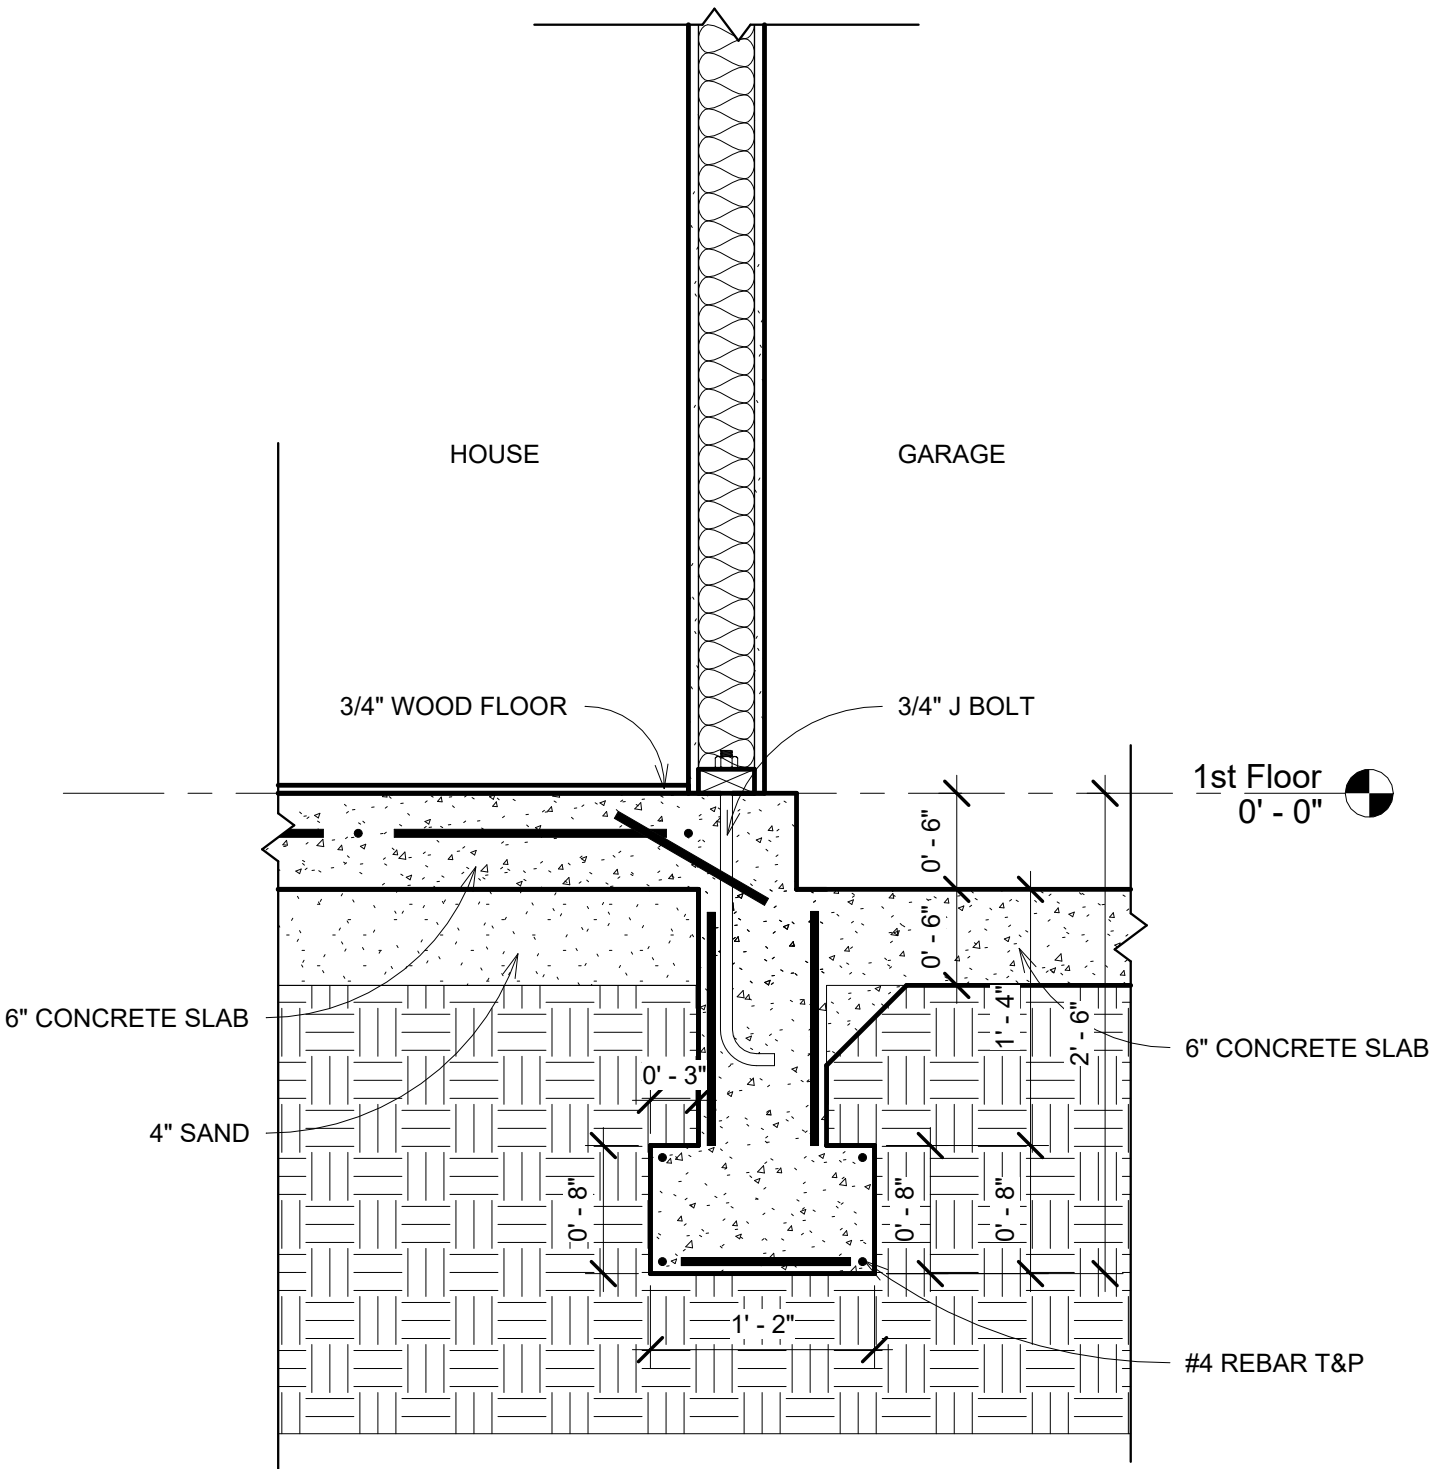


① Garage House Detail
1" = 1'-0"

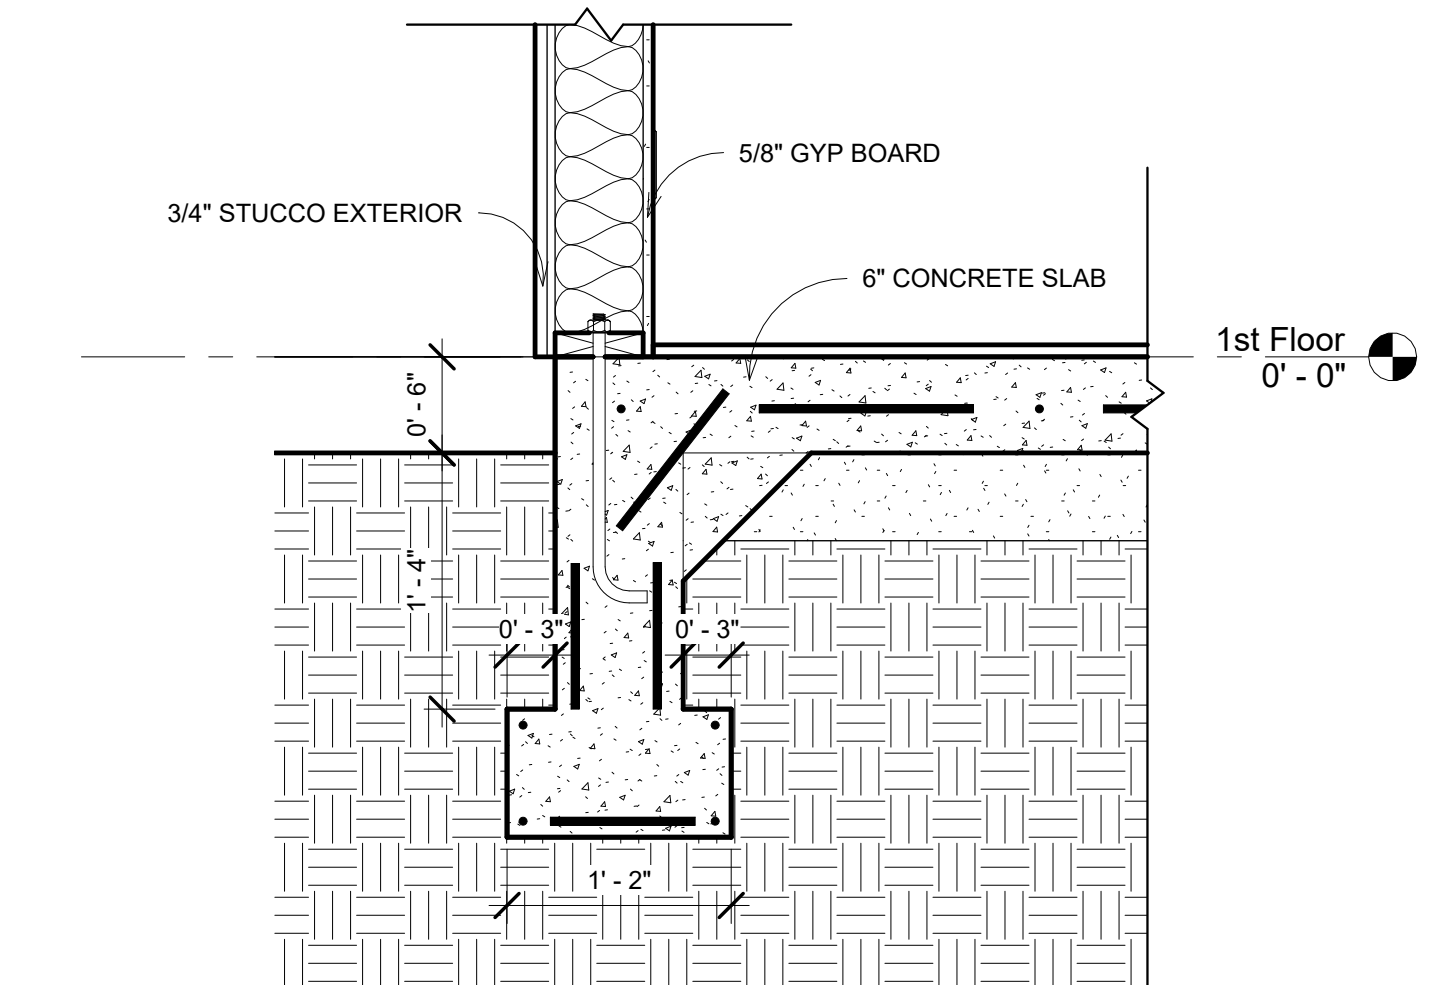


② Typical Exterior Footing
1" = 1'-0"

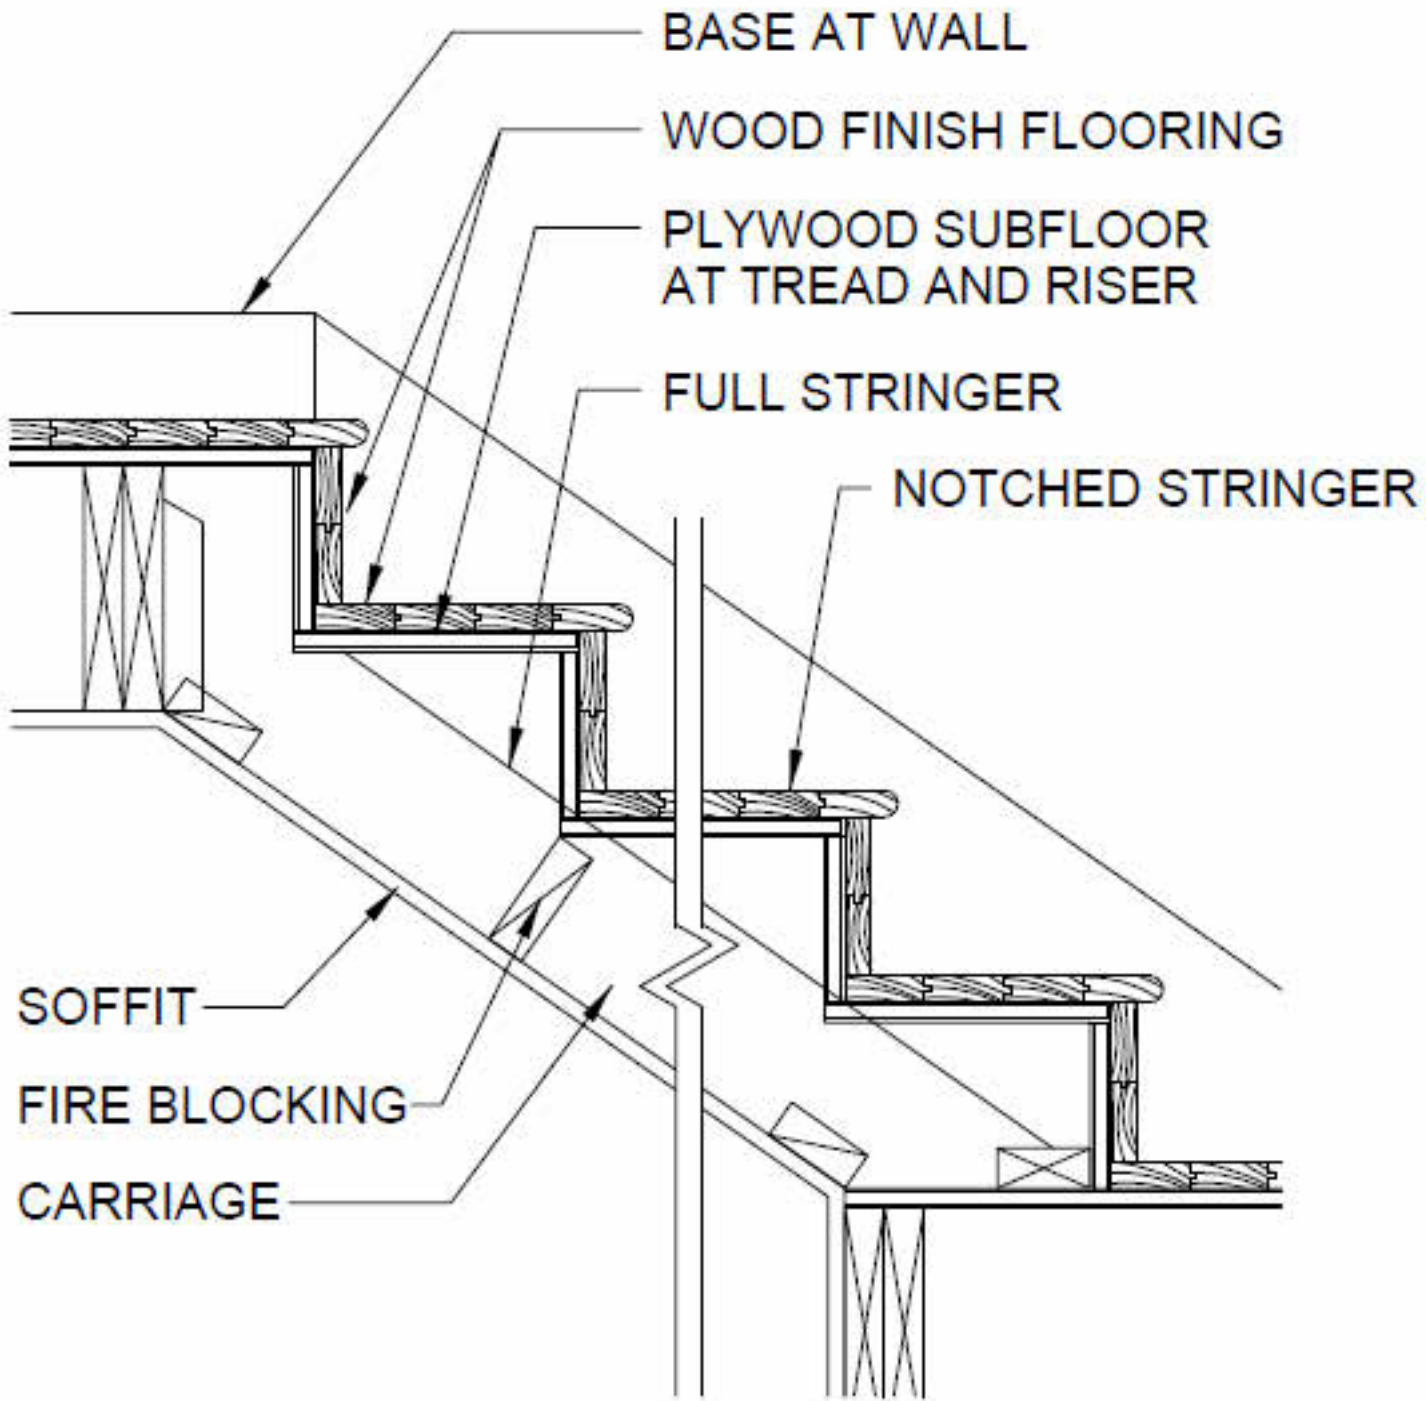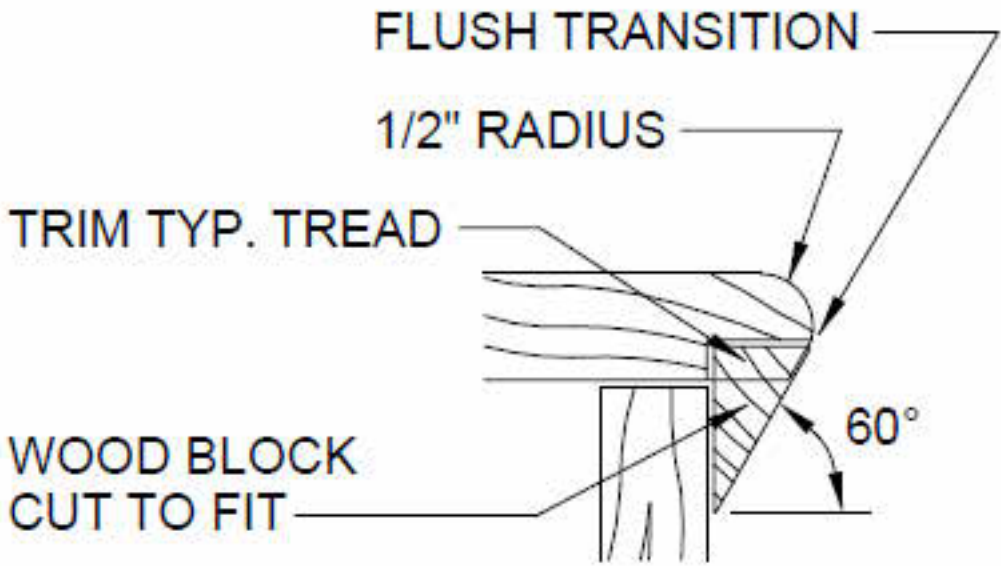


③ Stair Detail
1 1/2" = 1'-0"

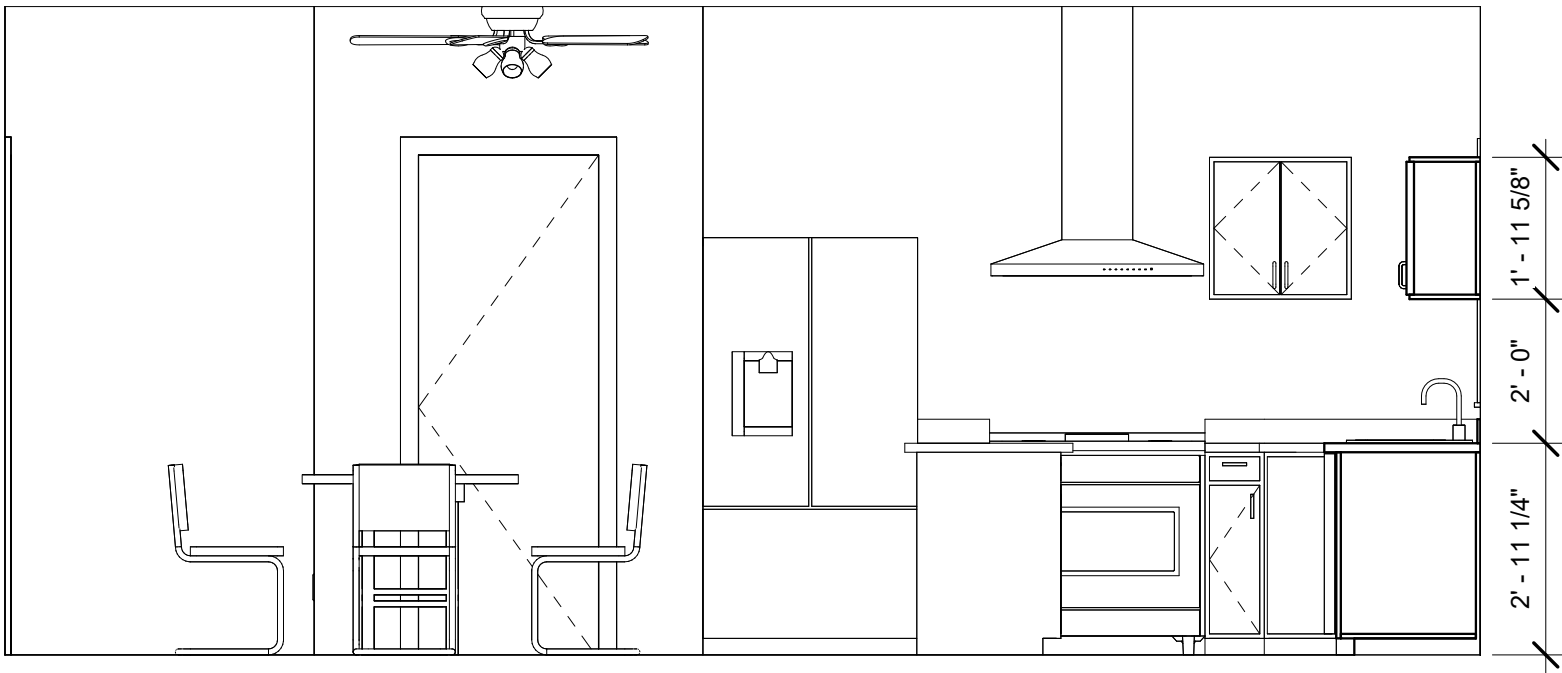


1
3/8" = 1'-0"

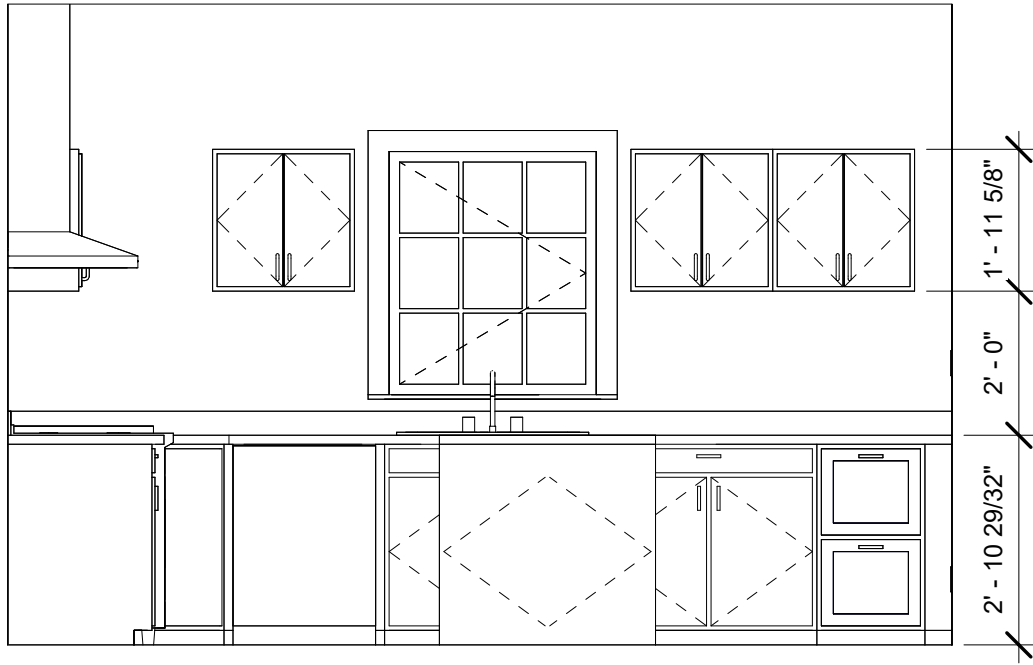


2
3/8" = 1'-0"

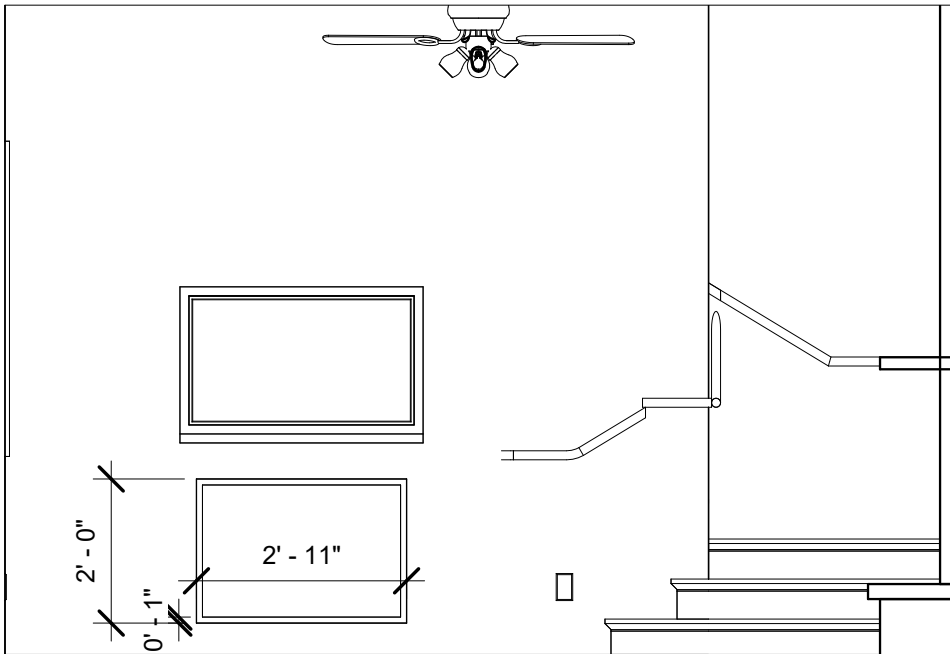

3
3/8" = 1'-0"

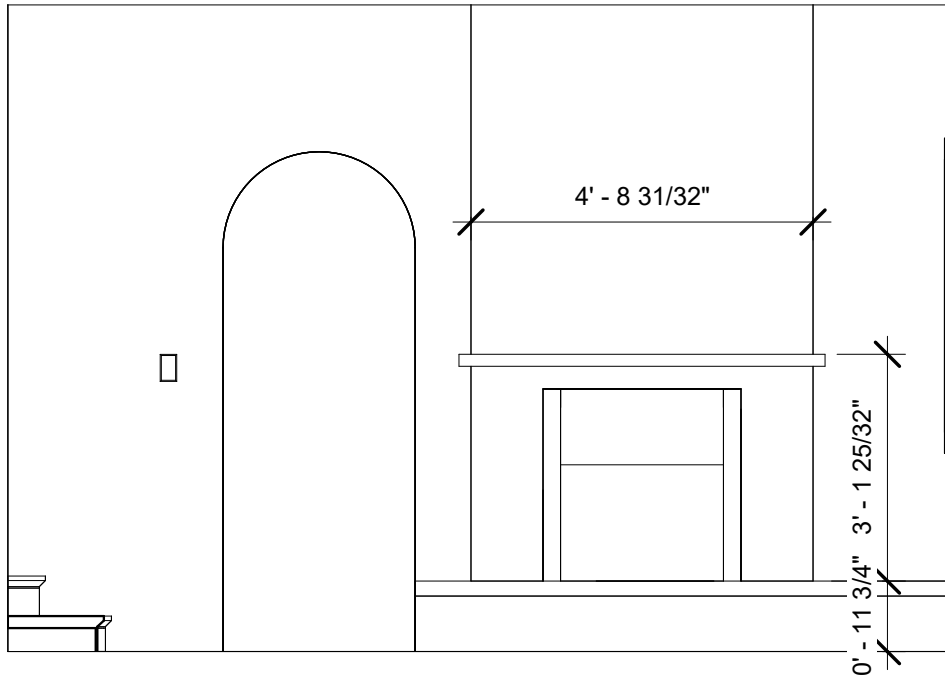

4
3/8" = 1'-0"

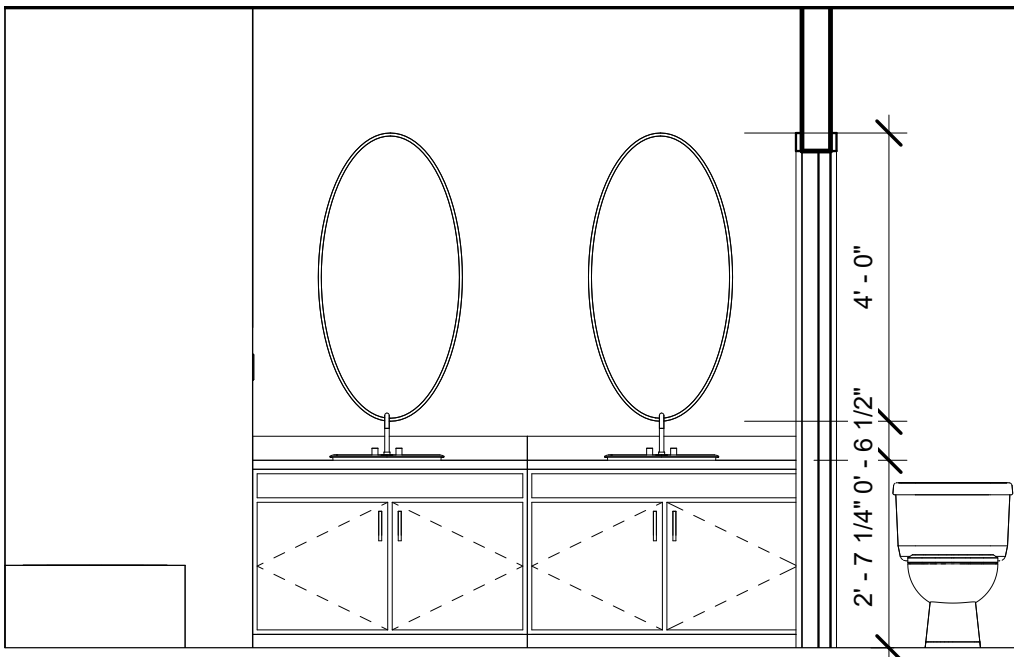

5
3/8" = 1'-0"



Saddleback College

www.saddleback.edu

Consultant
Address
Address
Phone
Fax
e-mail

Consultant
Address
Address
Phone
Fax
e-mail

Consultant
Address
Address
Phone
Fax
e-mail

Consultant
Address
Address
Phone
Fax
e-mail

Consultant
Address
Address
Phone
Fax
e-mail

No.	Description	Date

Joshua Tio	
ARCH 150 FINAL	
INTERIOR ELEVATIONS	
Project number	EX03
Date	7-15-2026
Drawn by	Joshua Tio
Checked by	Checker
A7.1	
3/8" = 1'-0"	



① Entrance Exterior View



② Garage Exterior View



Saddleback College

www.saddleback.edu

Consultant
Address
Address
Phone
Fax
e-mail

Consultant
Address
Address
Phone
Fax
e-mail

Consultant
Address
Address
Phone
Fax
e-mail

Consultant
Address
Address
Phone
Fax
e-mail

Consultant
Address
Address
Phone
Fax
e-mail

No.	Description	Date

Joshua Tio
ARCH 150 FINAL
HOUSE VIEWS

Project number	EX03
Date	7-15-2026
Drawn by	Joshua Tio
Checked by	Checker

A8.1



Saddleback College

www.saddleback.edu

Consultant
Address
Address
Phone
Fax
e-mail

Consultant
Address
Address
Phone
Fax
e-mail

Consultant
Address
Address
Phone
Fax
e-mail

Consultant
Address
Address
Phone
Fax
e-mail

Consultant
Address
Address
Phone
Fax
e-mail

No.	Description	Date

Joshua Tio
ARCH 150 FINAL
HOUSE VIEWS

Project number	EX03
Date	7-15-2026
Drawn by	Joshua Tio
Checked by	Checker

A8.2



1 Hall Interior View



3 Living Interior View



2 Kitchen Interior View



4 Master Bedroom Interior View